

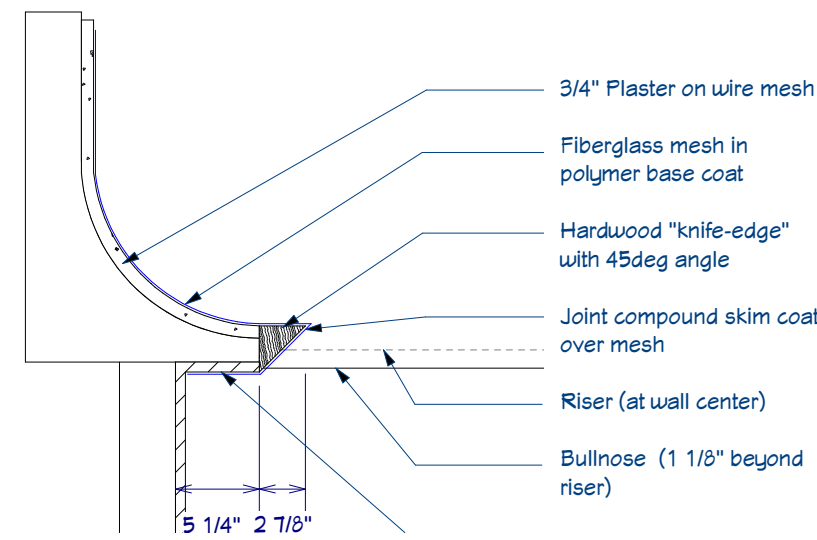


All ends to be cut off as required

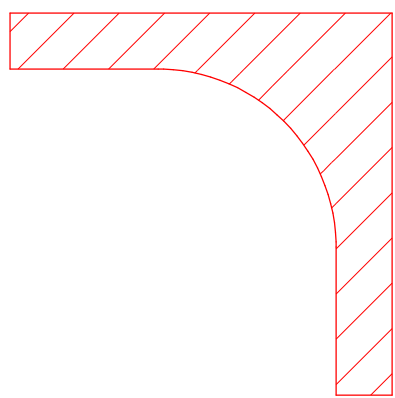

Plywood Shoe dimensions

Scale: 1" = 1'

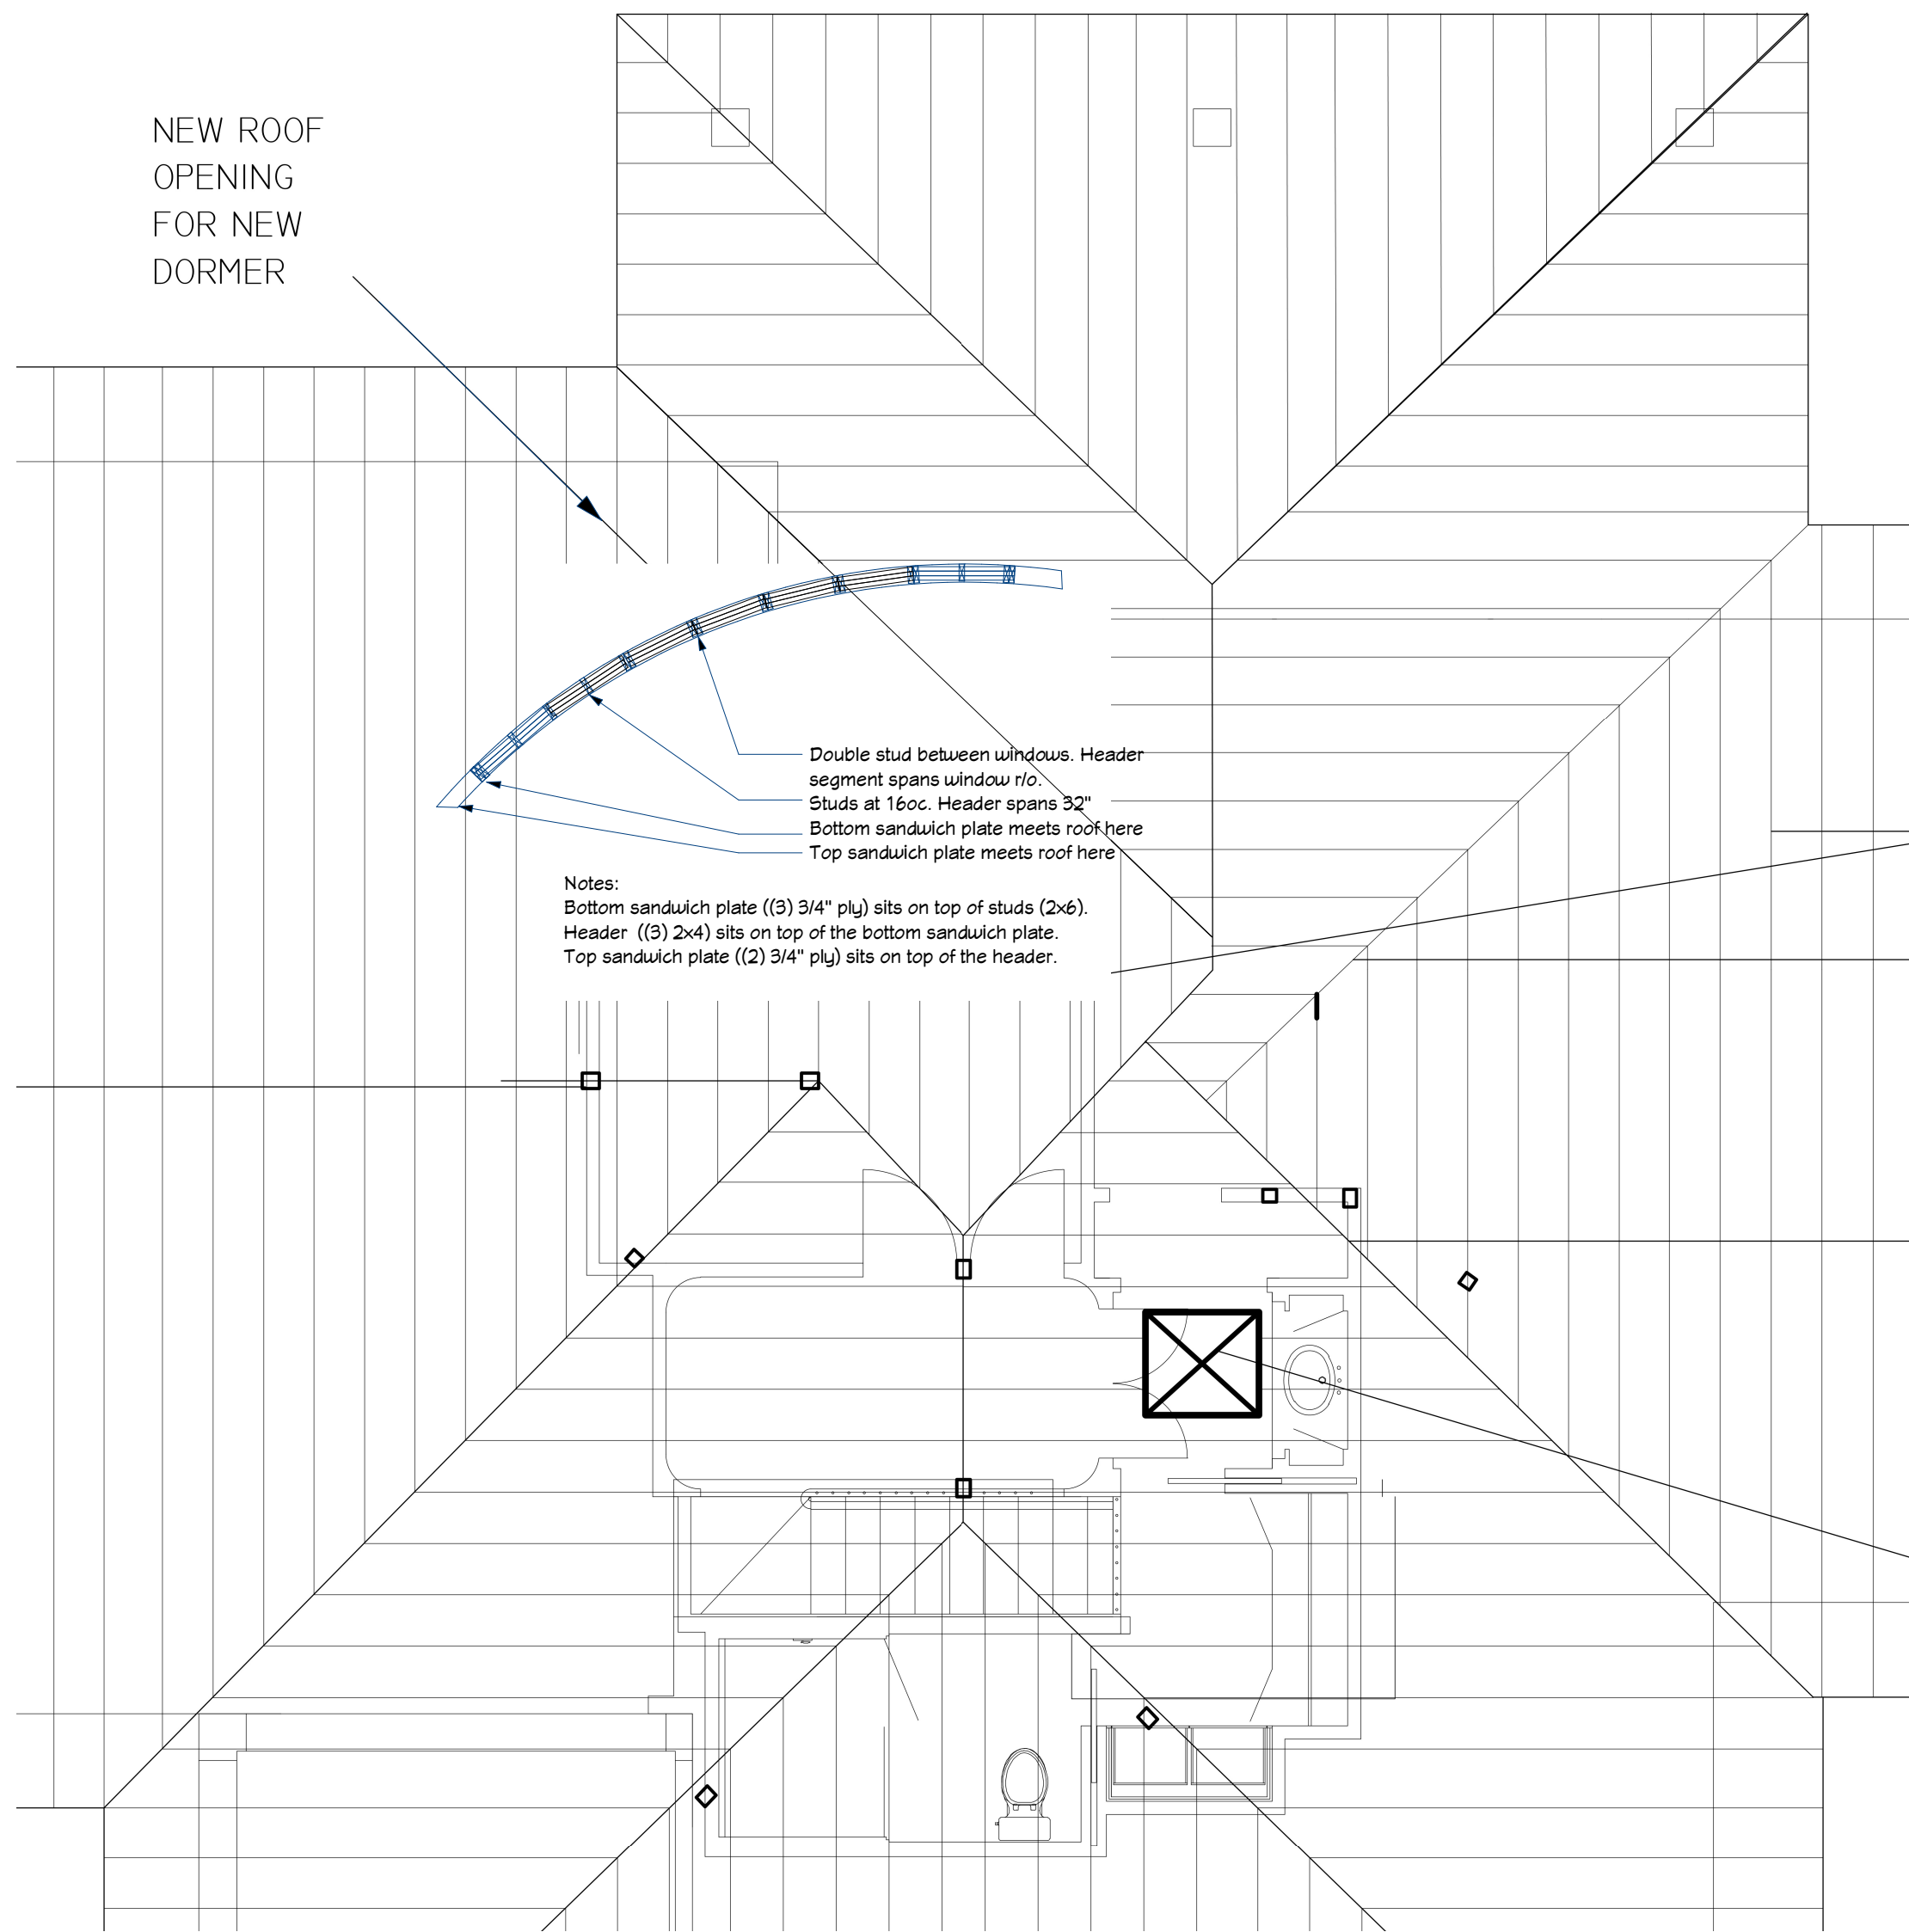


Curved Dormer Wall Detail

NTS


- | Post | Description |
|------|---|
| 1 | Keep |
| 2 | Remove. Add Teco plates at ridge/hip/valley connection. |
| 3 | Keep |
| 4 | Replace with post on header. Add Teco plates at ridge/hip connection. |
| 5 | Remove. Add Teco plates and double rafters at ridge/hip connection. |
| 6 | Keep |
| 7 | Remove. Add collar ties over bathroom |
| 8 | New. Supports header and continues to blocking at rafters above. |
| 9 | New. Supports header and continues to blocking at rafters above. |
| 10 | New. Notches into hip above. |
| 11 | New. Notches into hip above. |
| 12 | New. Mid-support for new doubled rafter |
| 13 | New. Mid-support for new doubled rafter |

Set of rafters currently "locked" into the structure between the valley and ridge/hip members, that will no longer help to support the roof structure once they are cut and gusseted to the curved rafters.

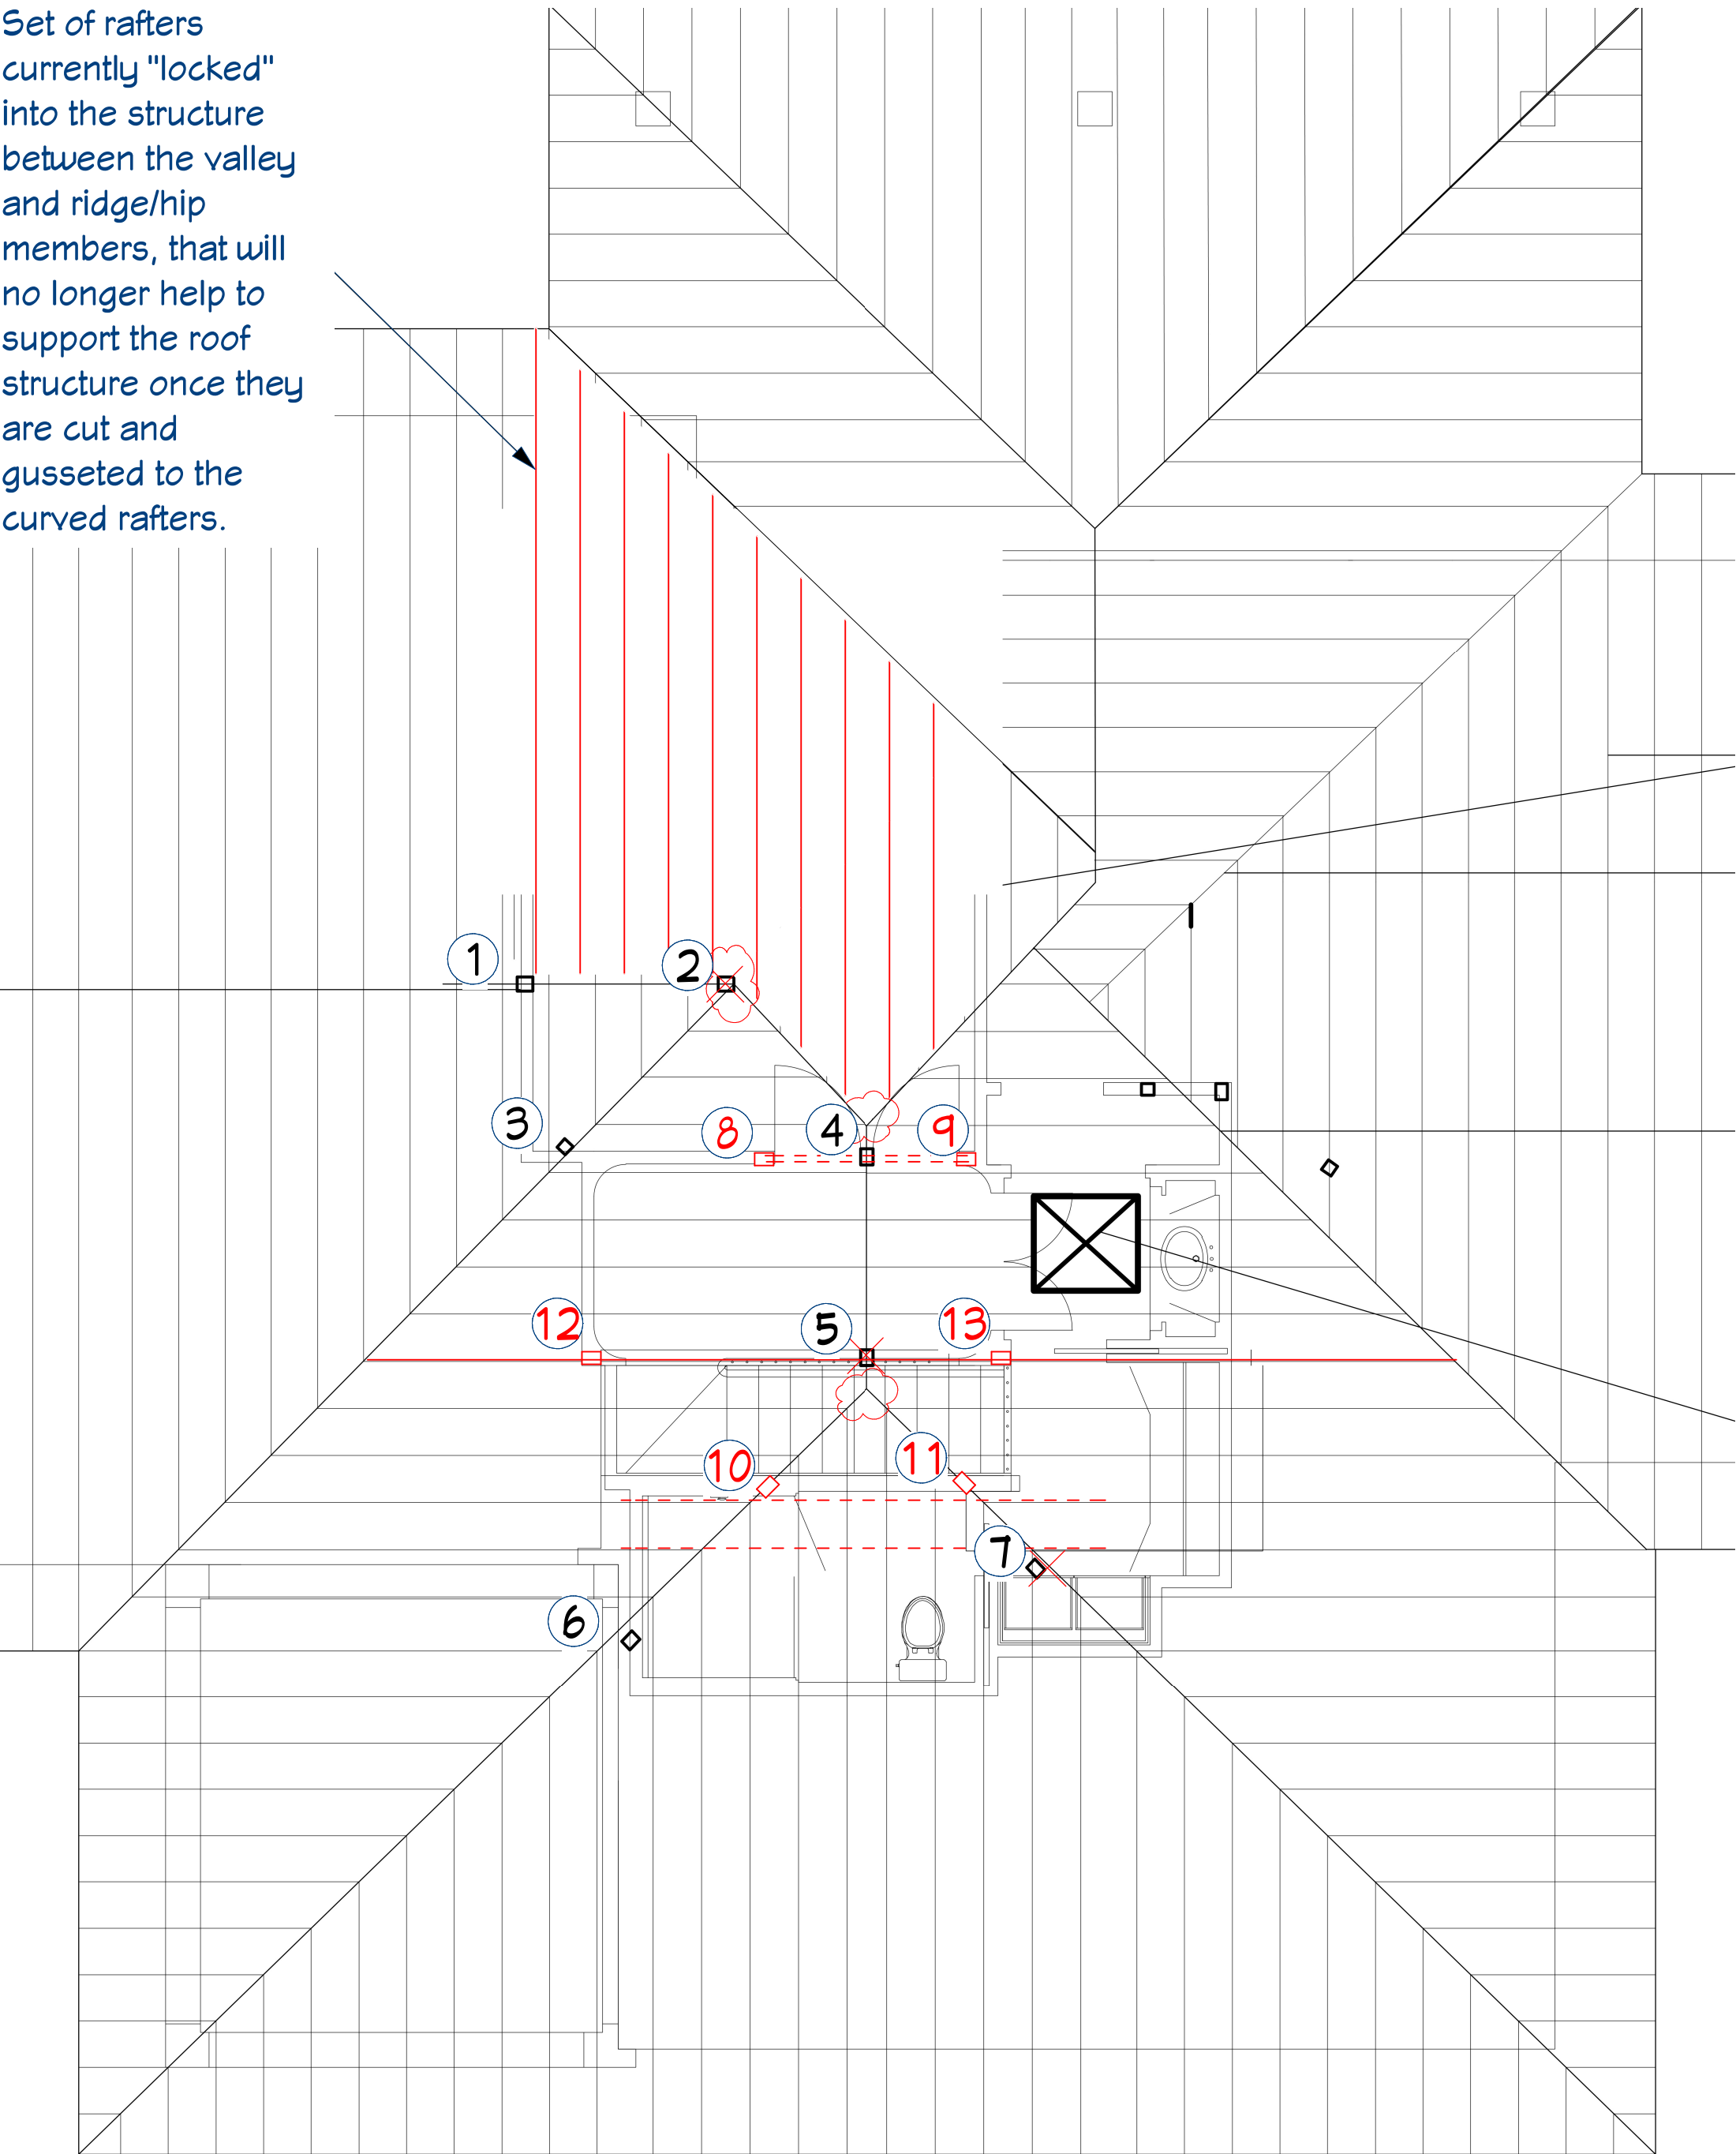

Roof Structural Posts

NTS

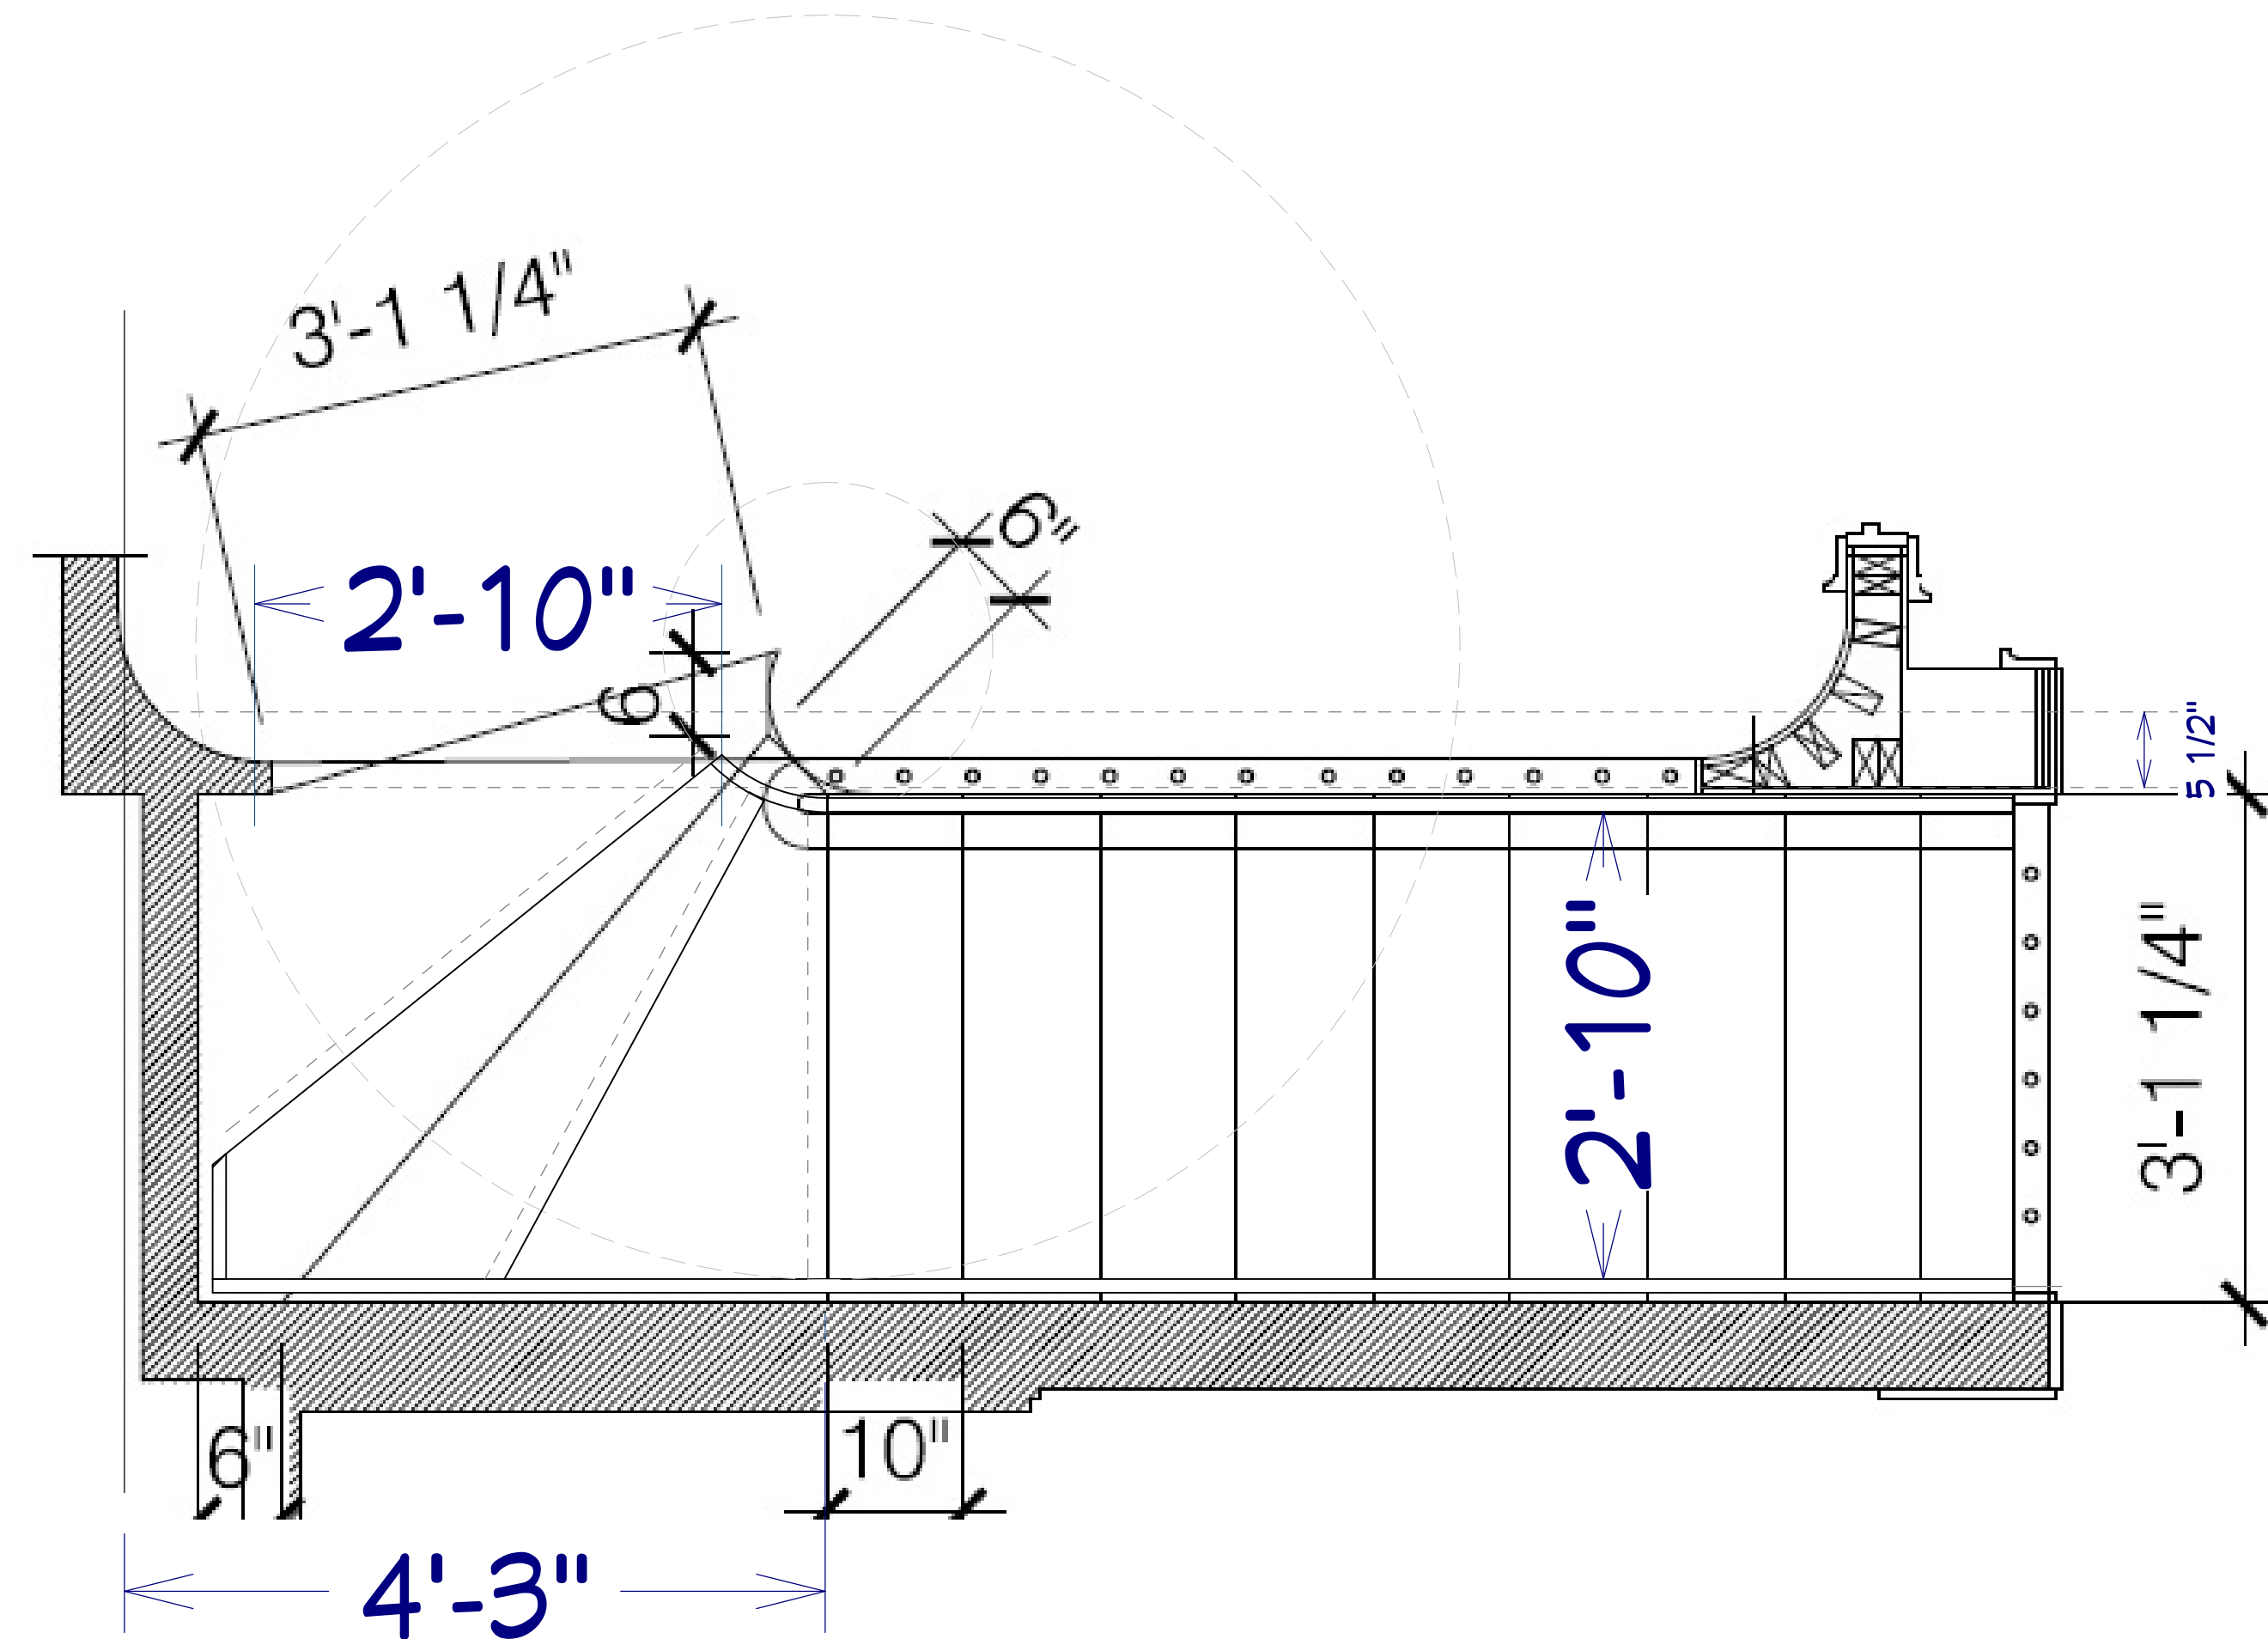

Winders

Scale: 1" = 1'

REVISION TABLE			
NUMBER	DATE	REVISED BY	DESCRIPTION


Webb Builders, Inc.
Design and Construction
www.dwebbste.com

Mill's Renovation
Shop Drawings

DATE:
11/30/2015

SCALE:


SHEET:
3

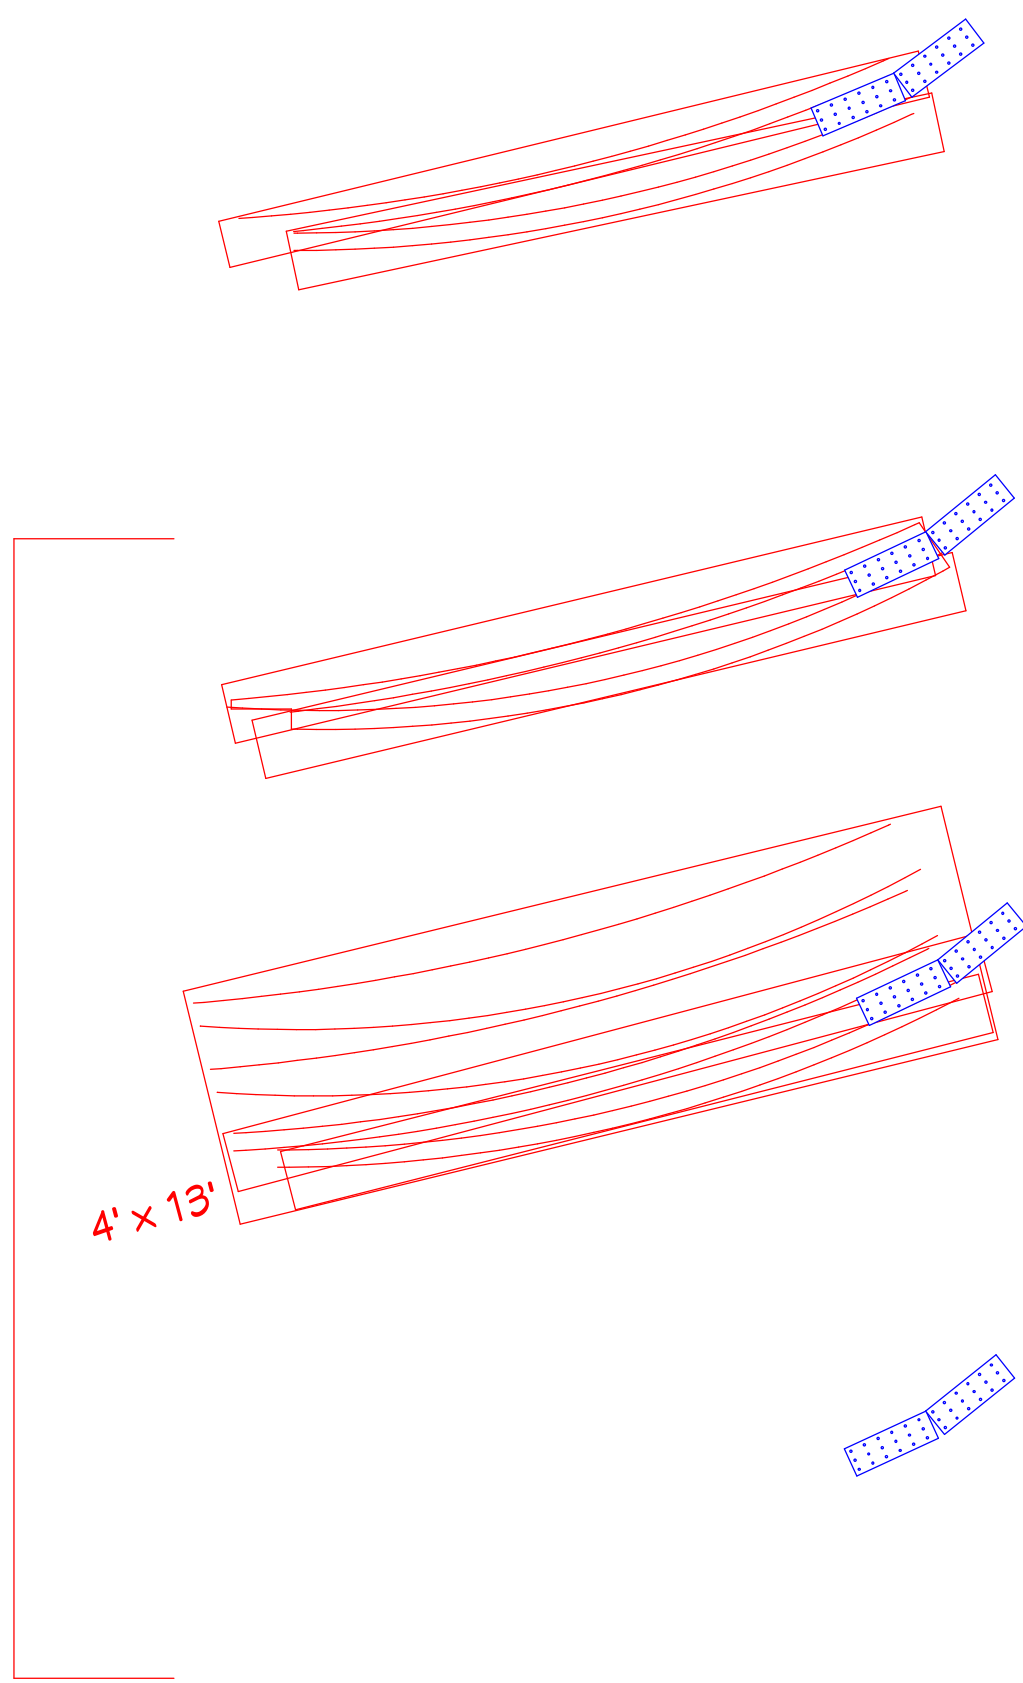

Rafter List and Template Sourcing


NTS

Gusset Pattern 1

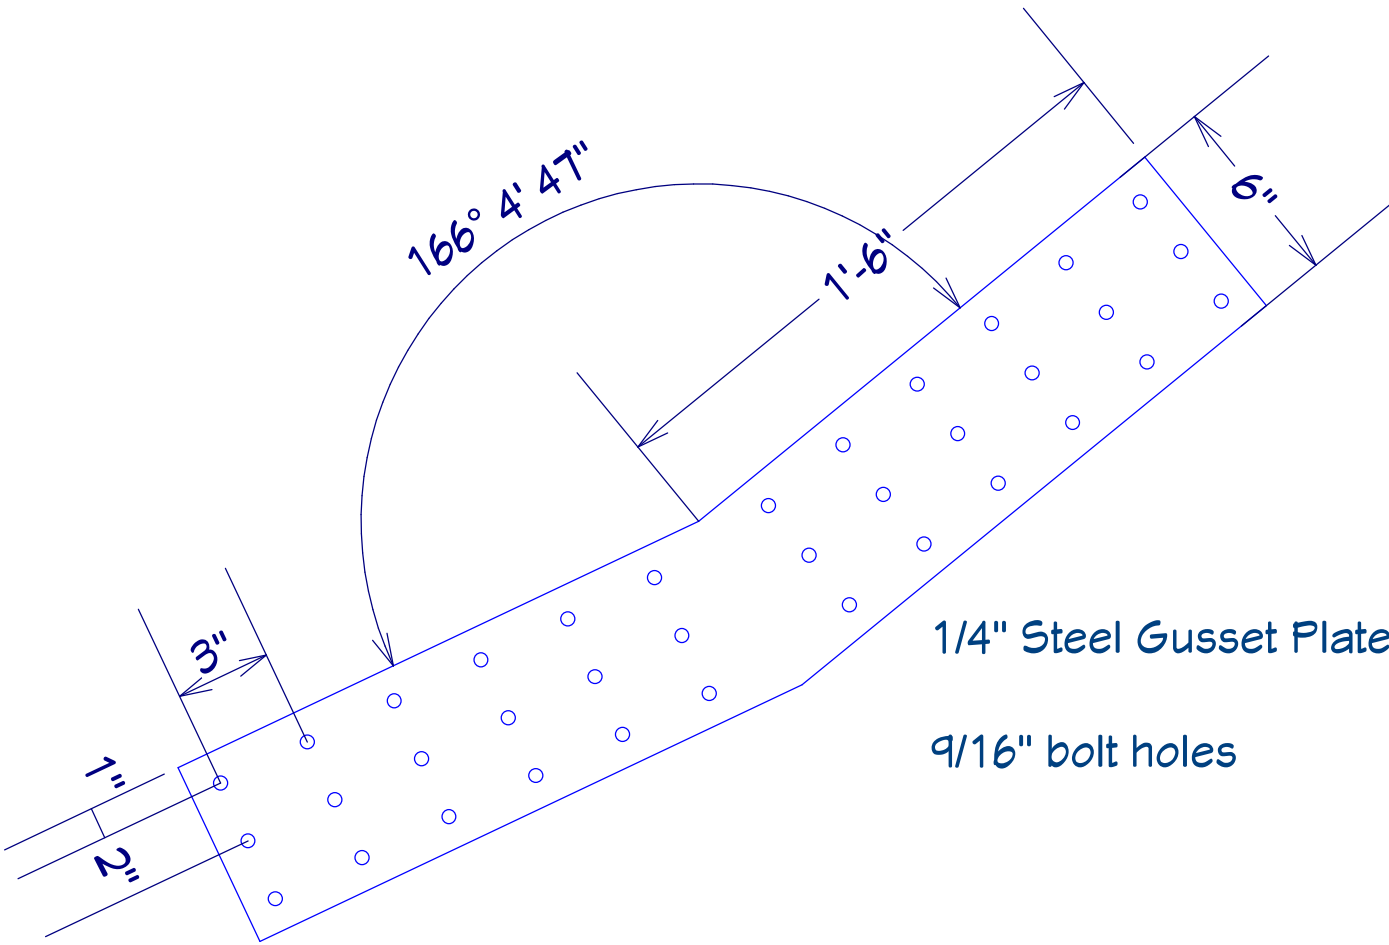


Gusset Pattern 1

Scale: 2" = 1'

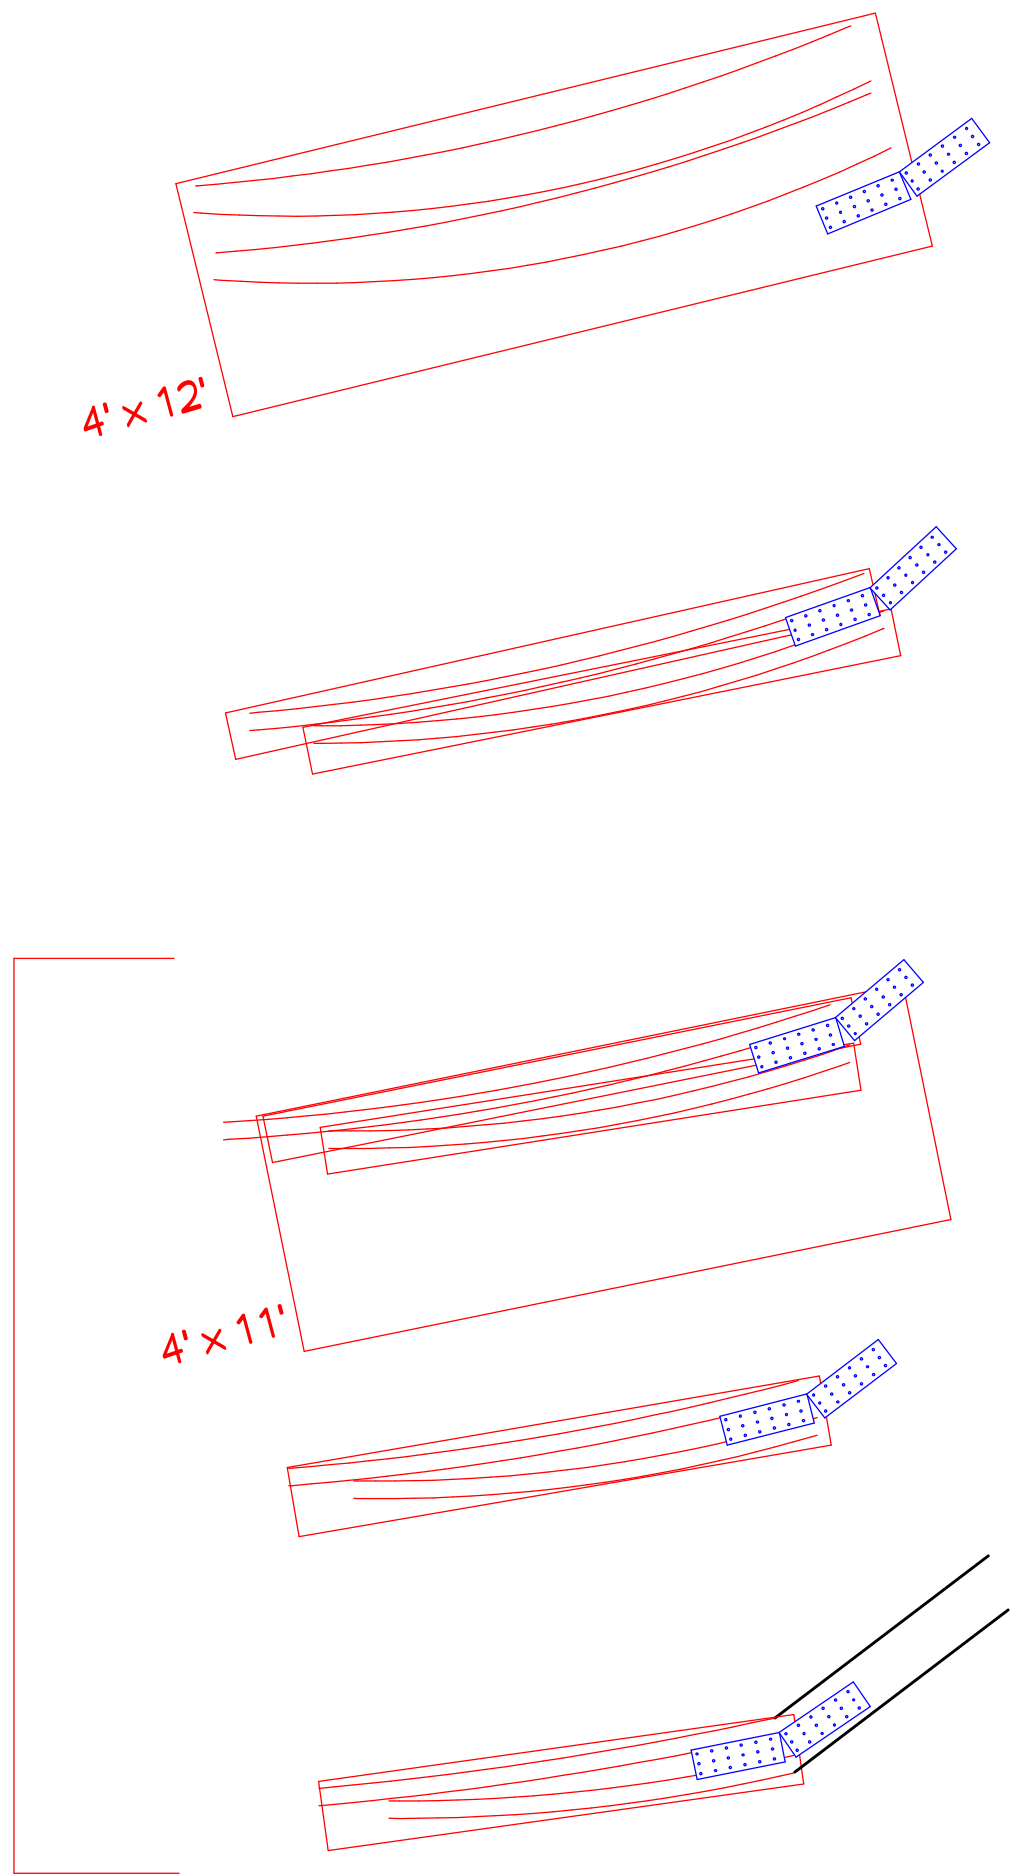

Gusset Pattern 2

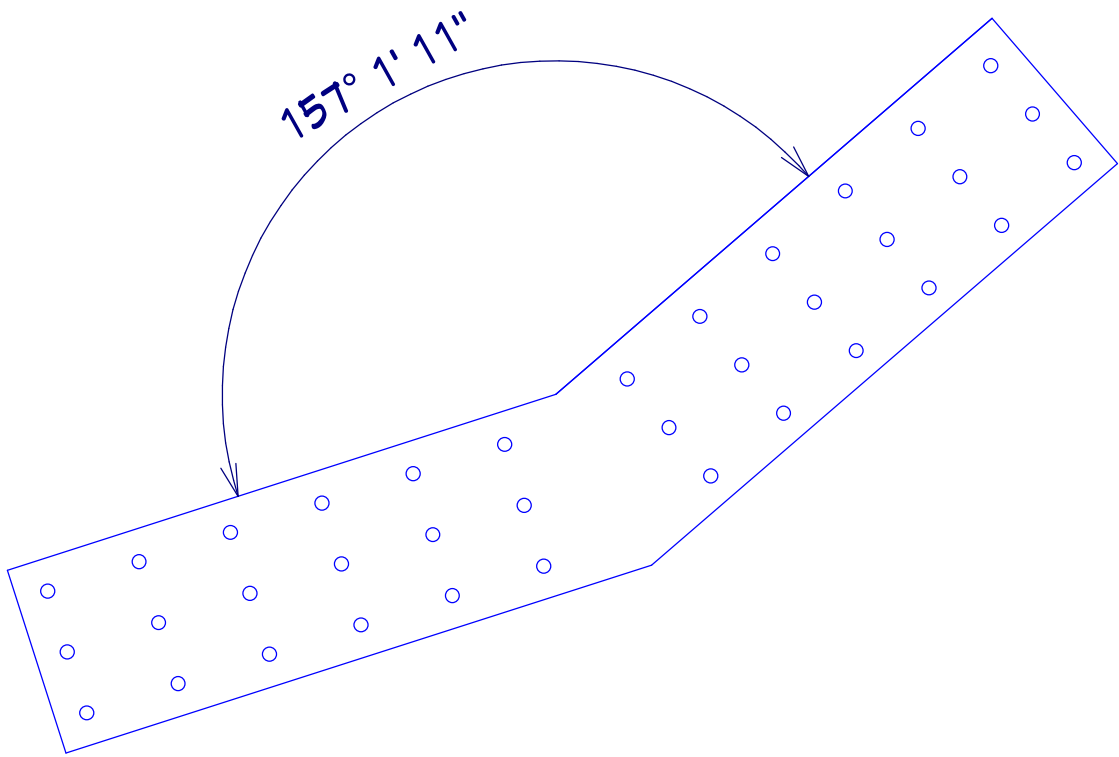

Gusset Pattern 2

Scale: 2" = 1'

REVISION TABLE	
NUMBER	DATE

Webb Builders, Inc.
Design and Construction
www.dwebb-site.com


Mill's Renovation
Shop Drawings

DATE:

11/30/2015


SCALE:

SHEET:

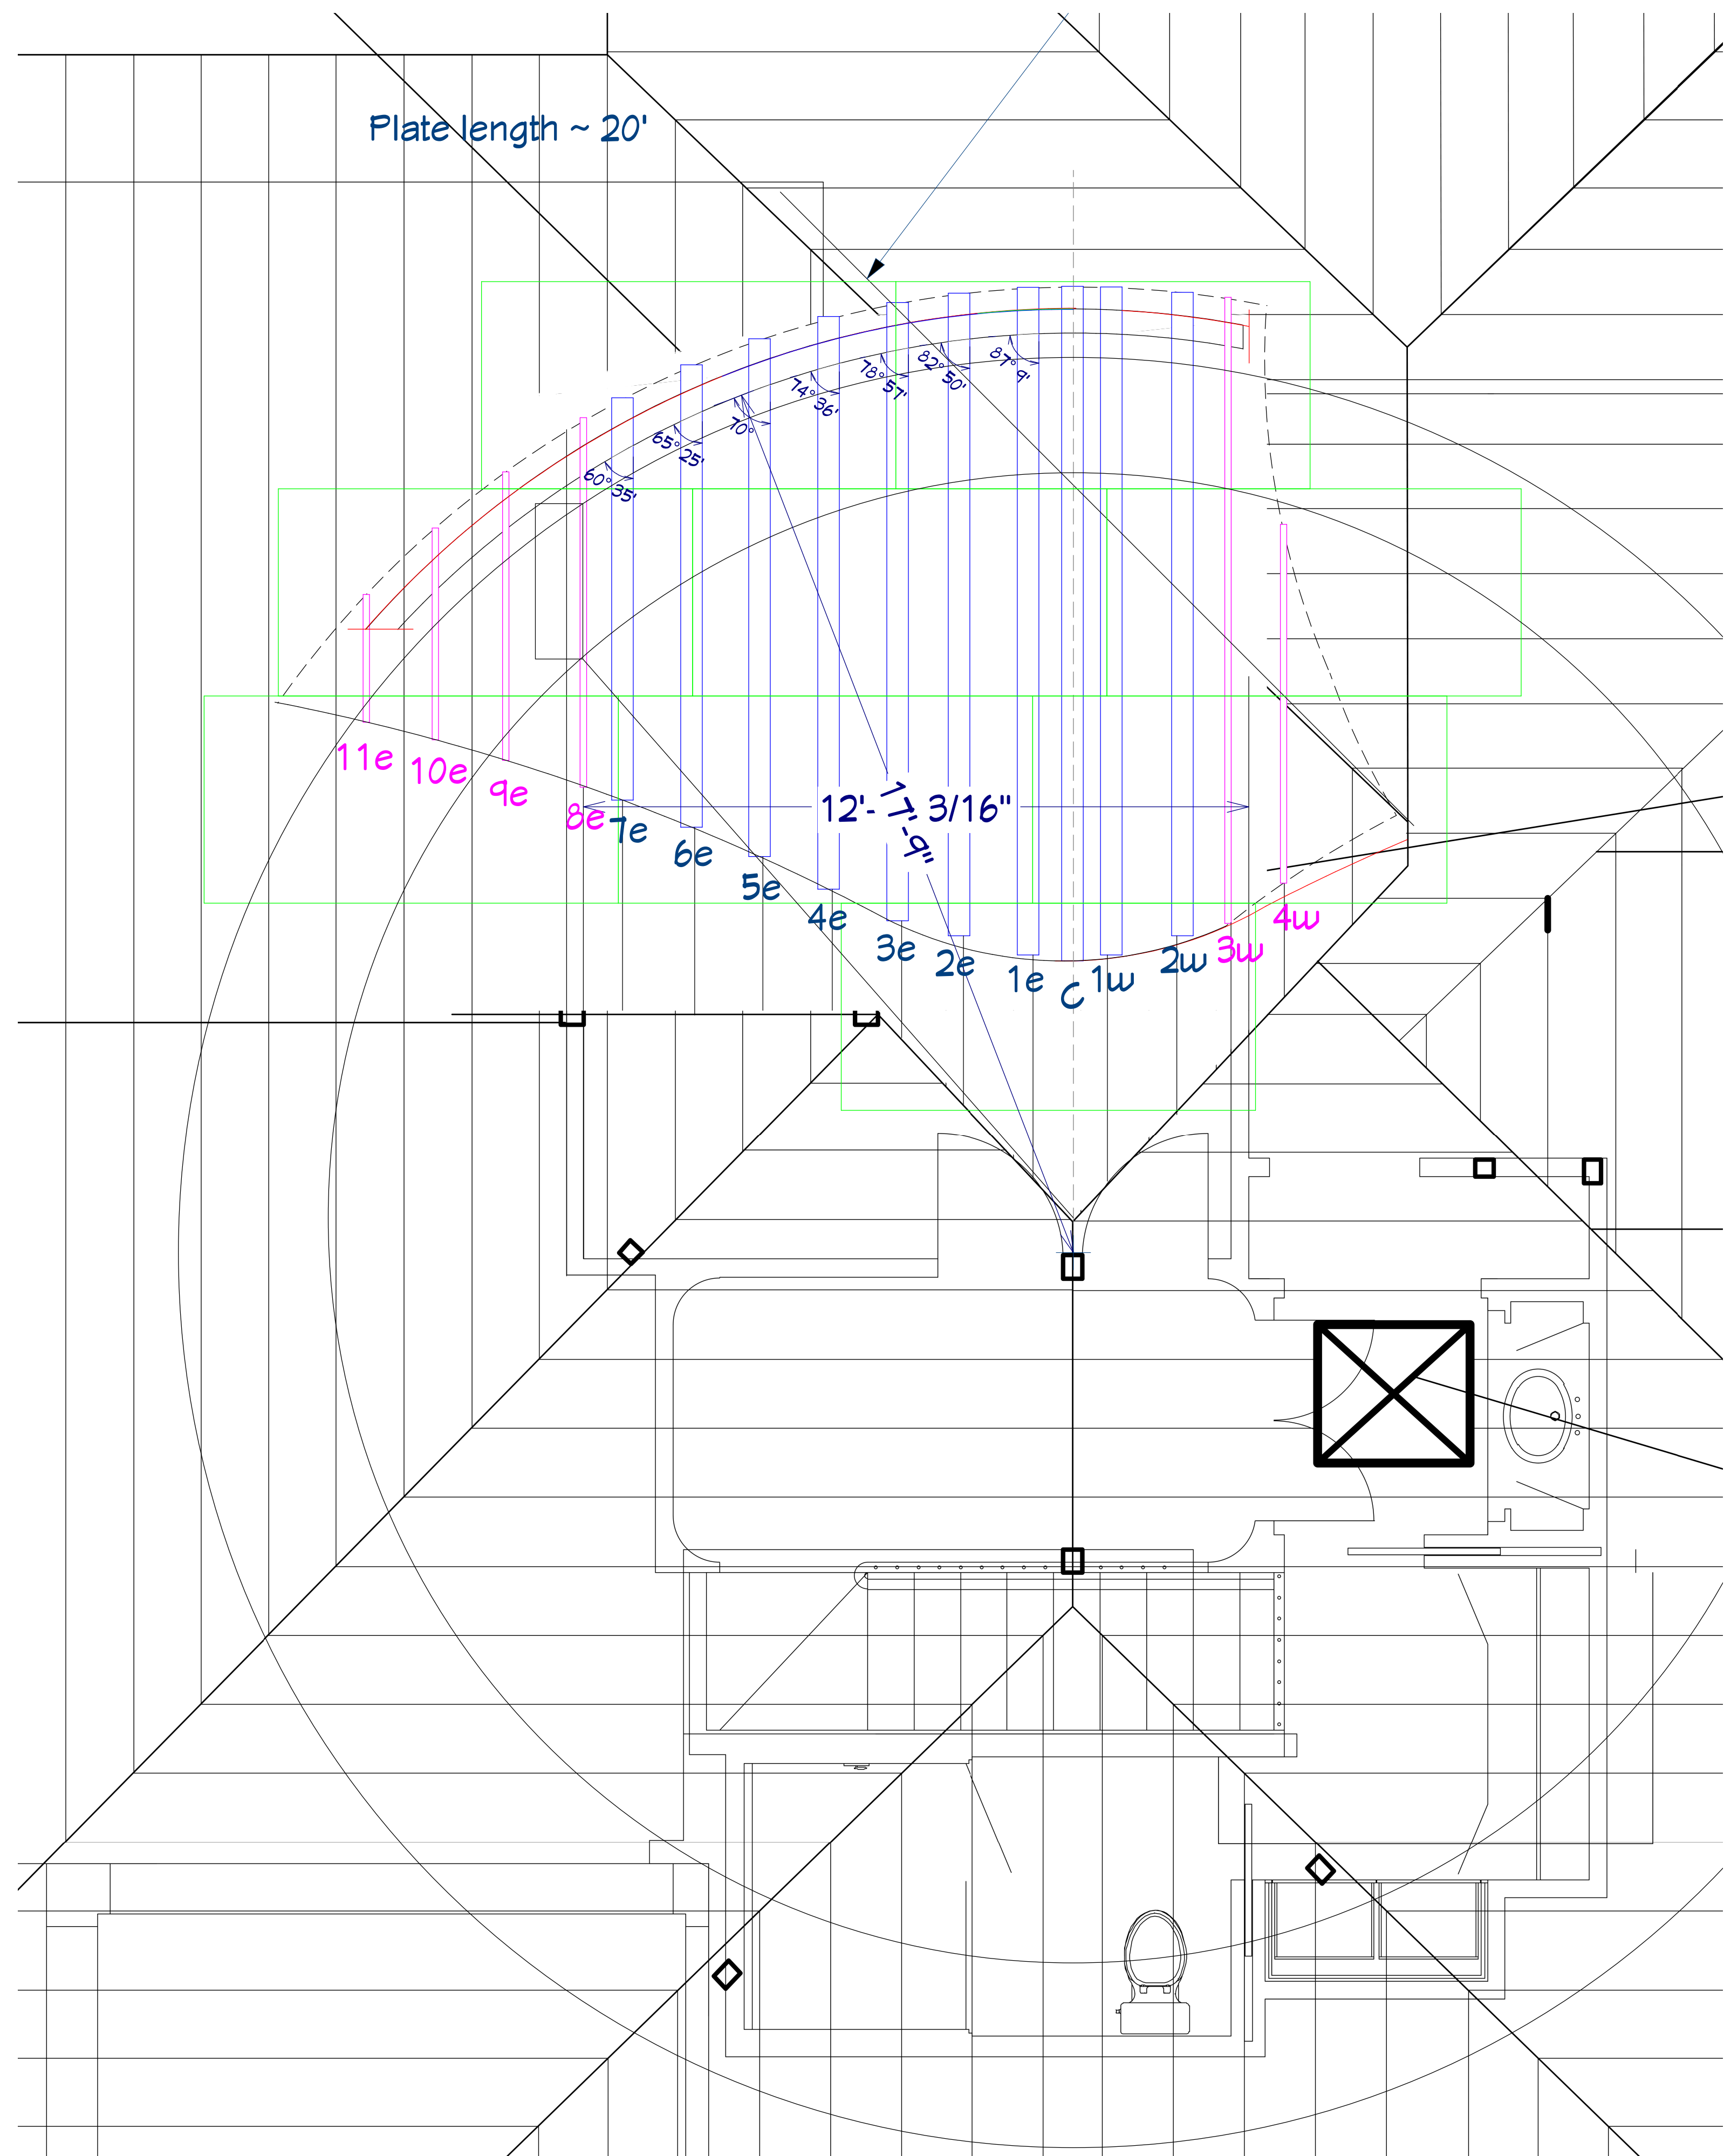

Dormer Rafters

Scale: 1/2" = 1'

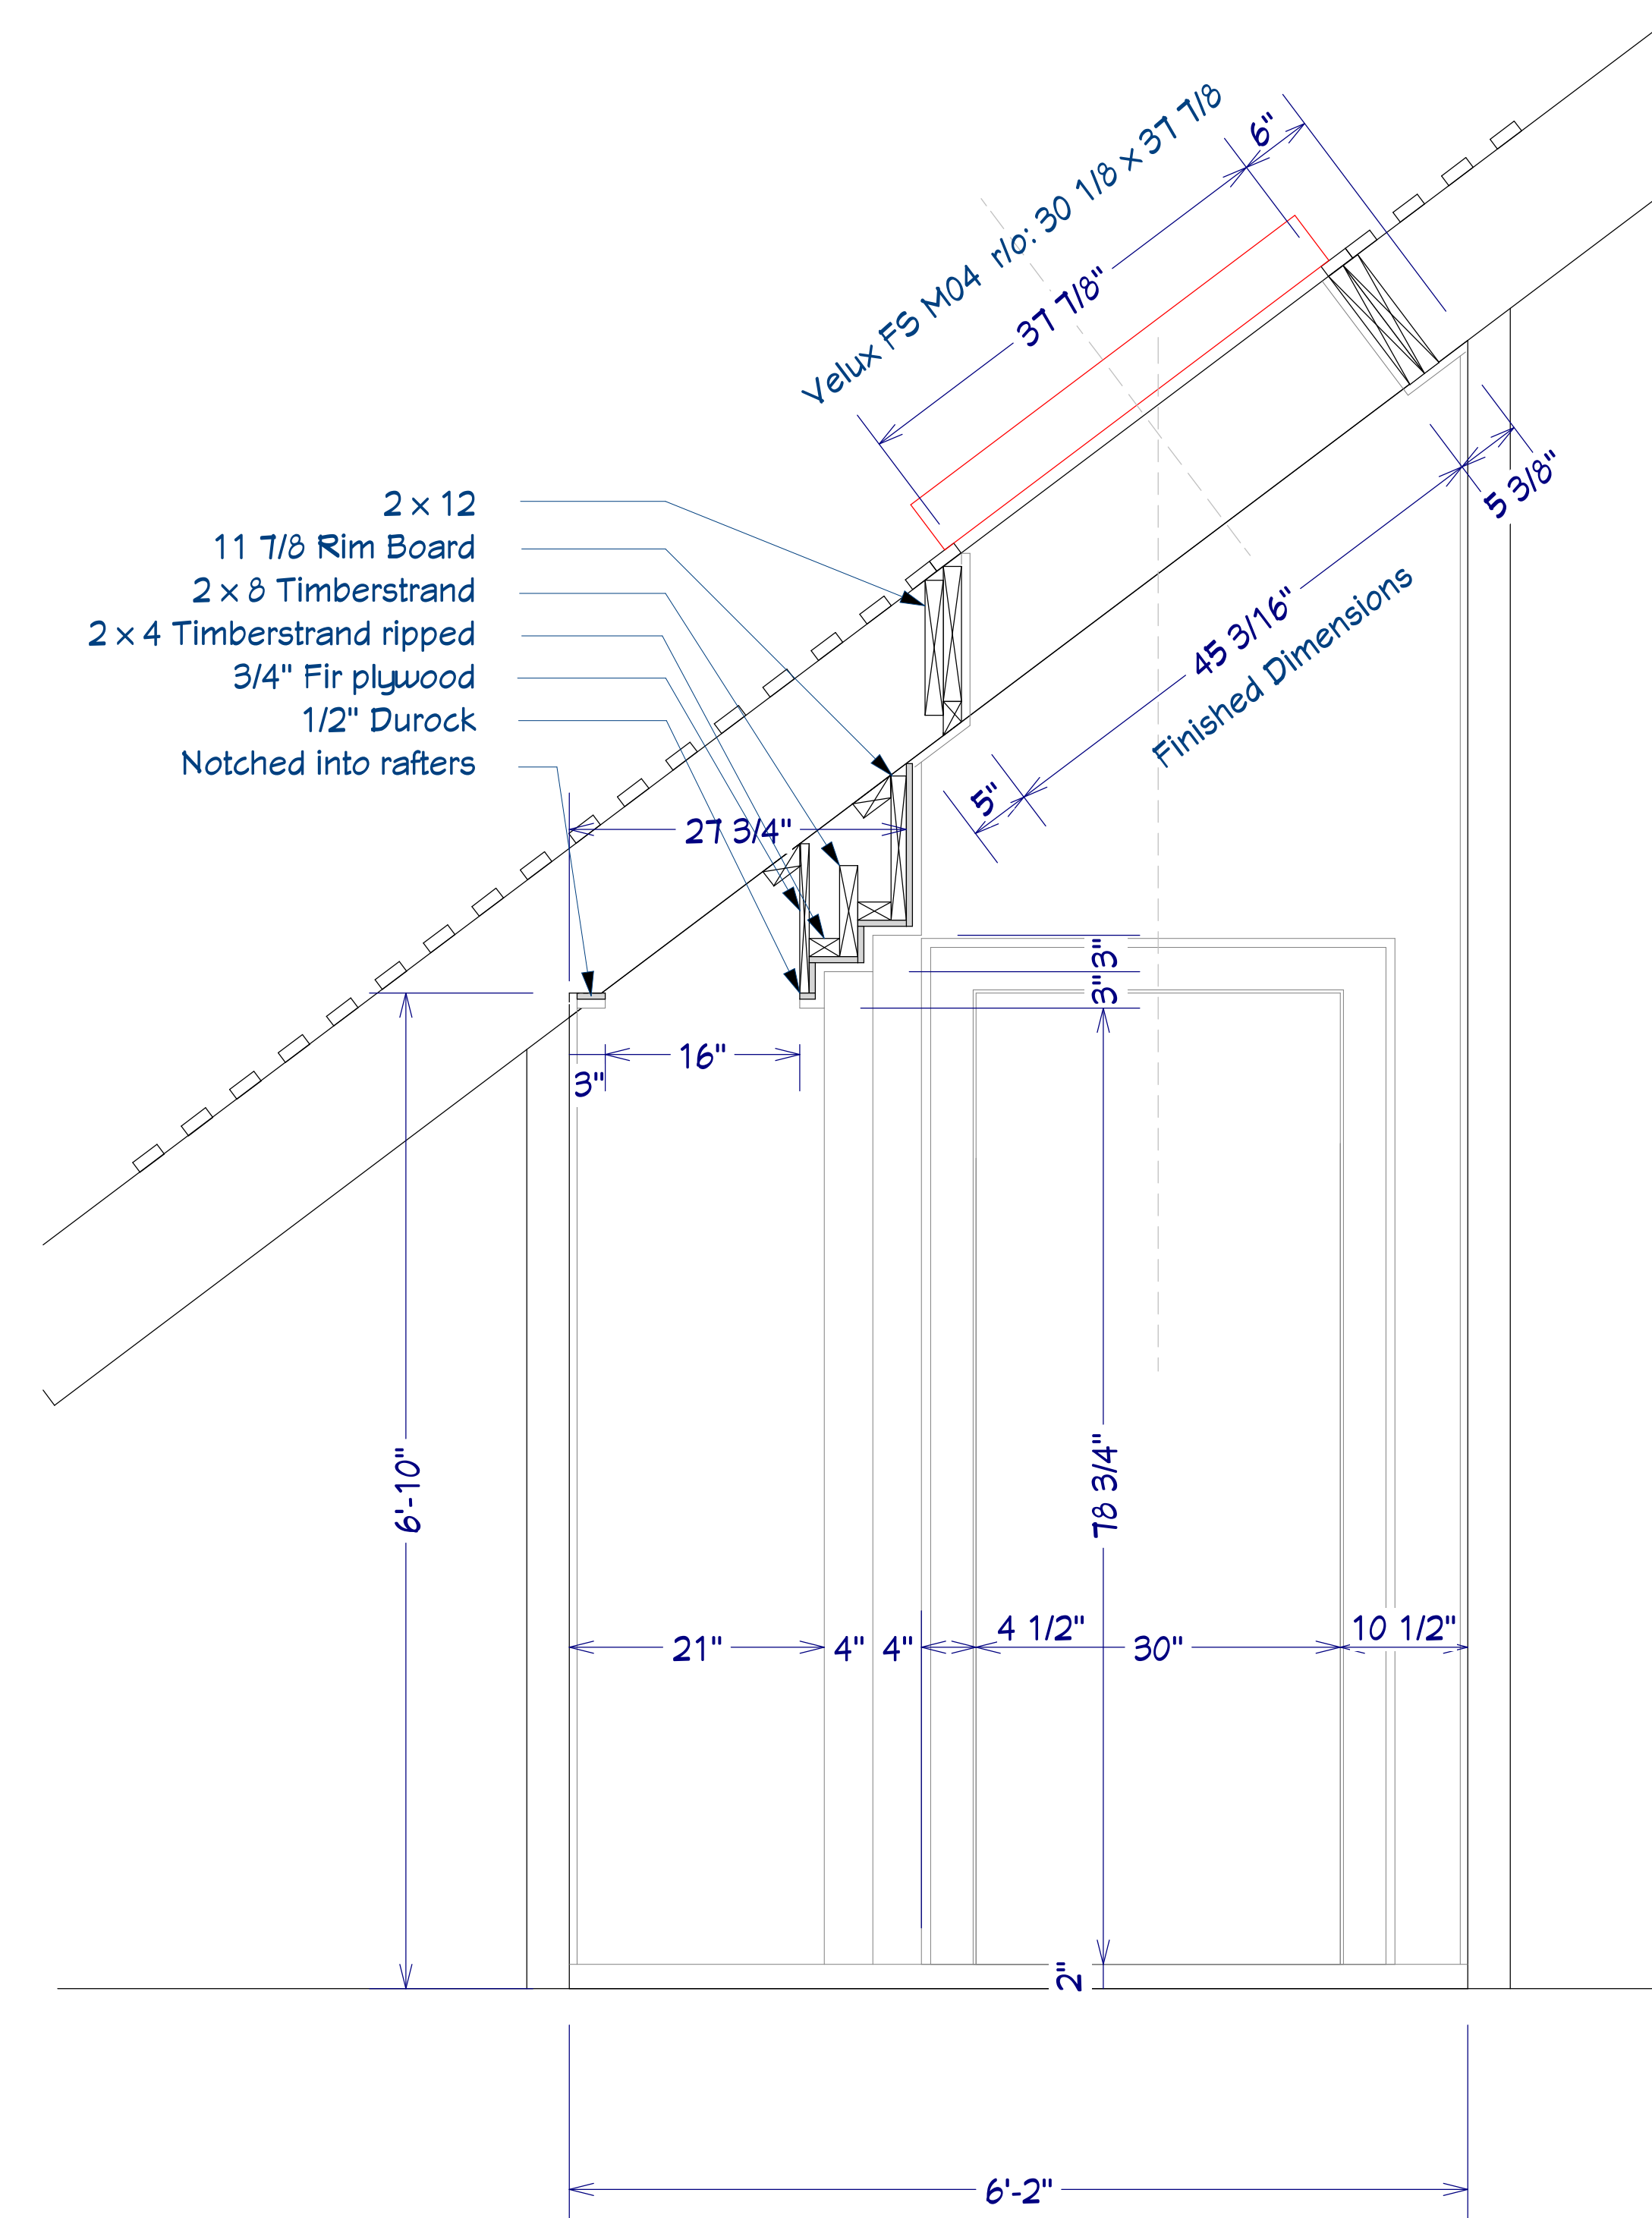

Section at Lavatory

Scale: 1" = 1'

REVISION TABLE	
NUMBER	DATE

Webb Builders, Inc.
Design and Construction
www.dwebb-site.com


Mill's Renovation
Shop Drawings

DATE:

11/30/2015

SCALE:

SHEET:

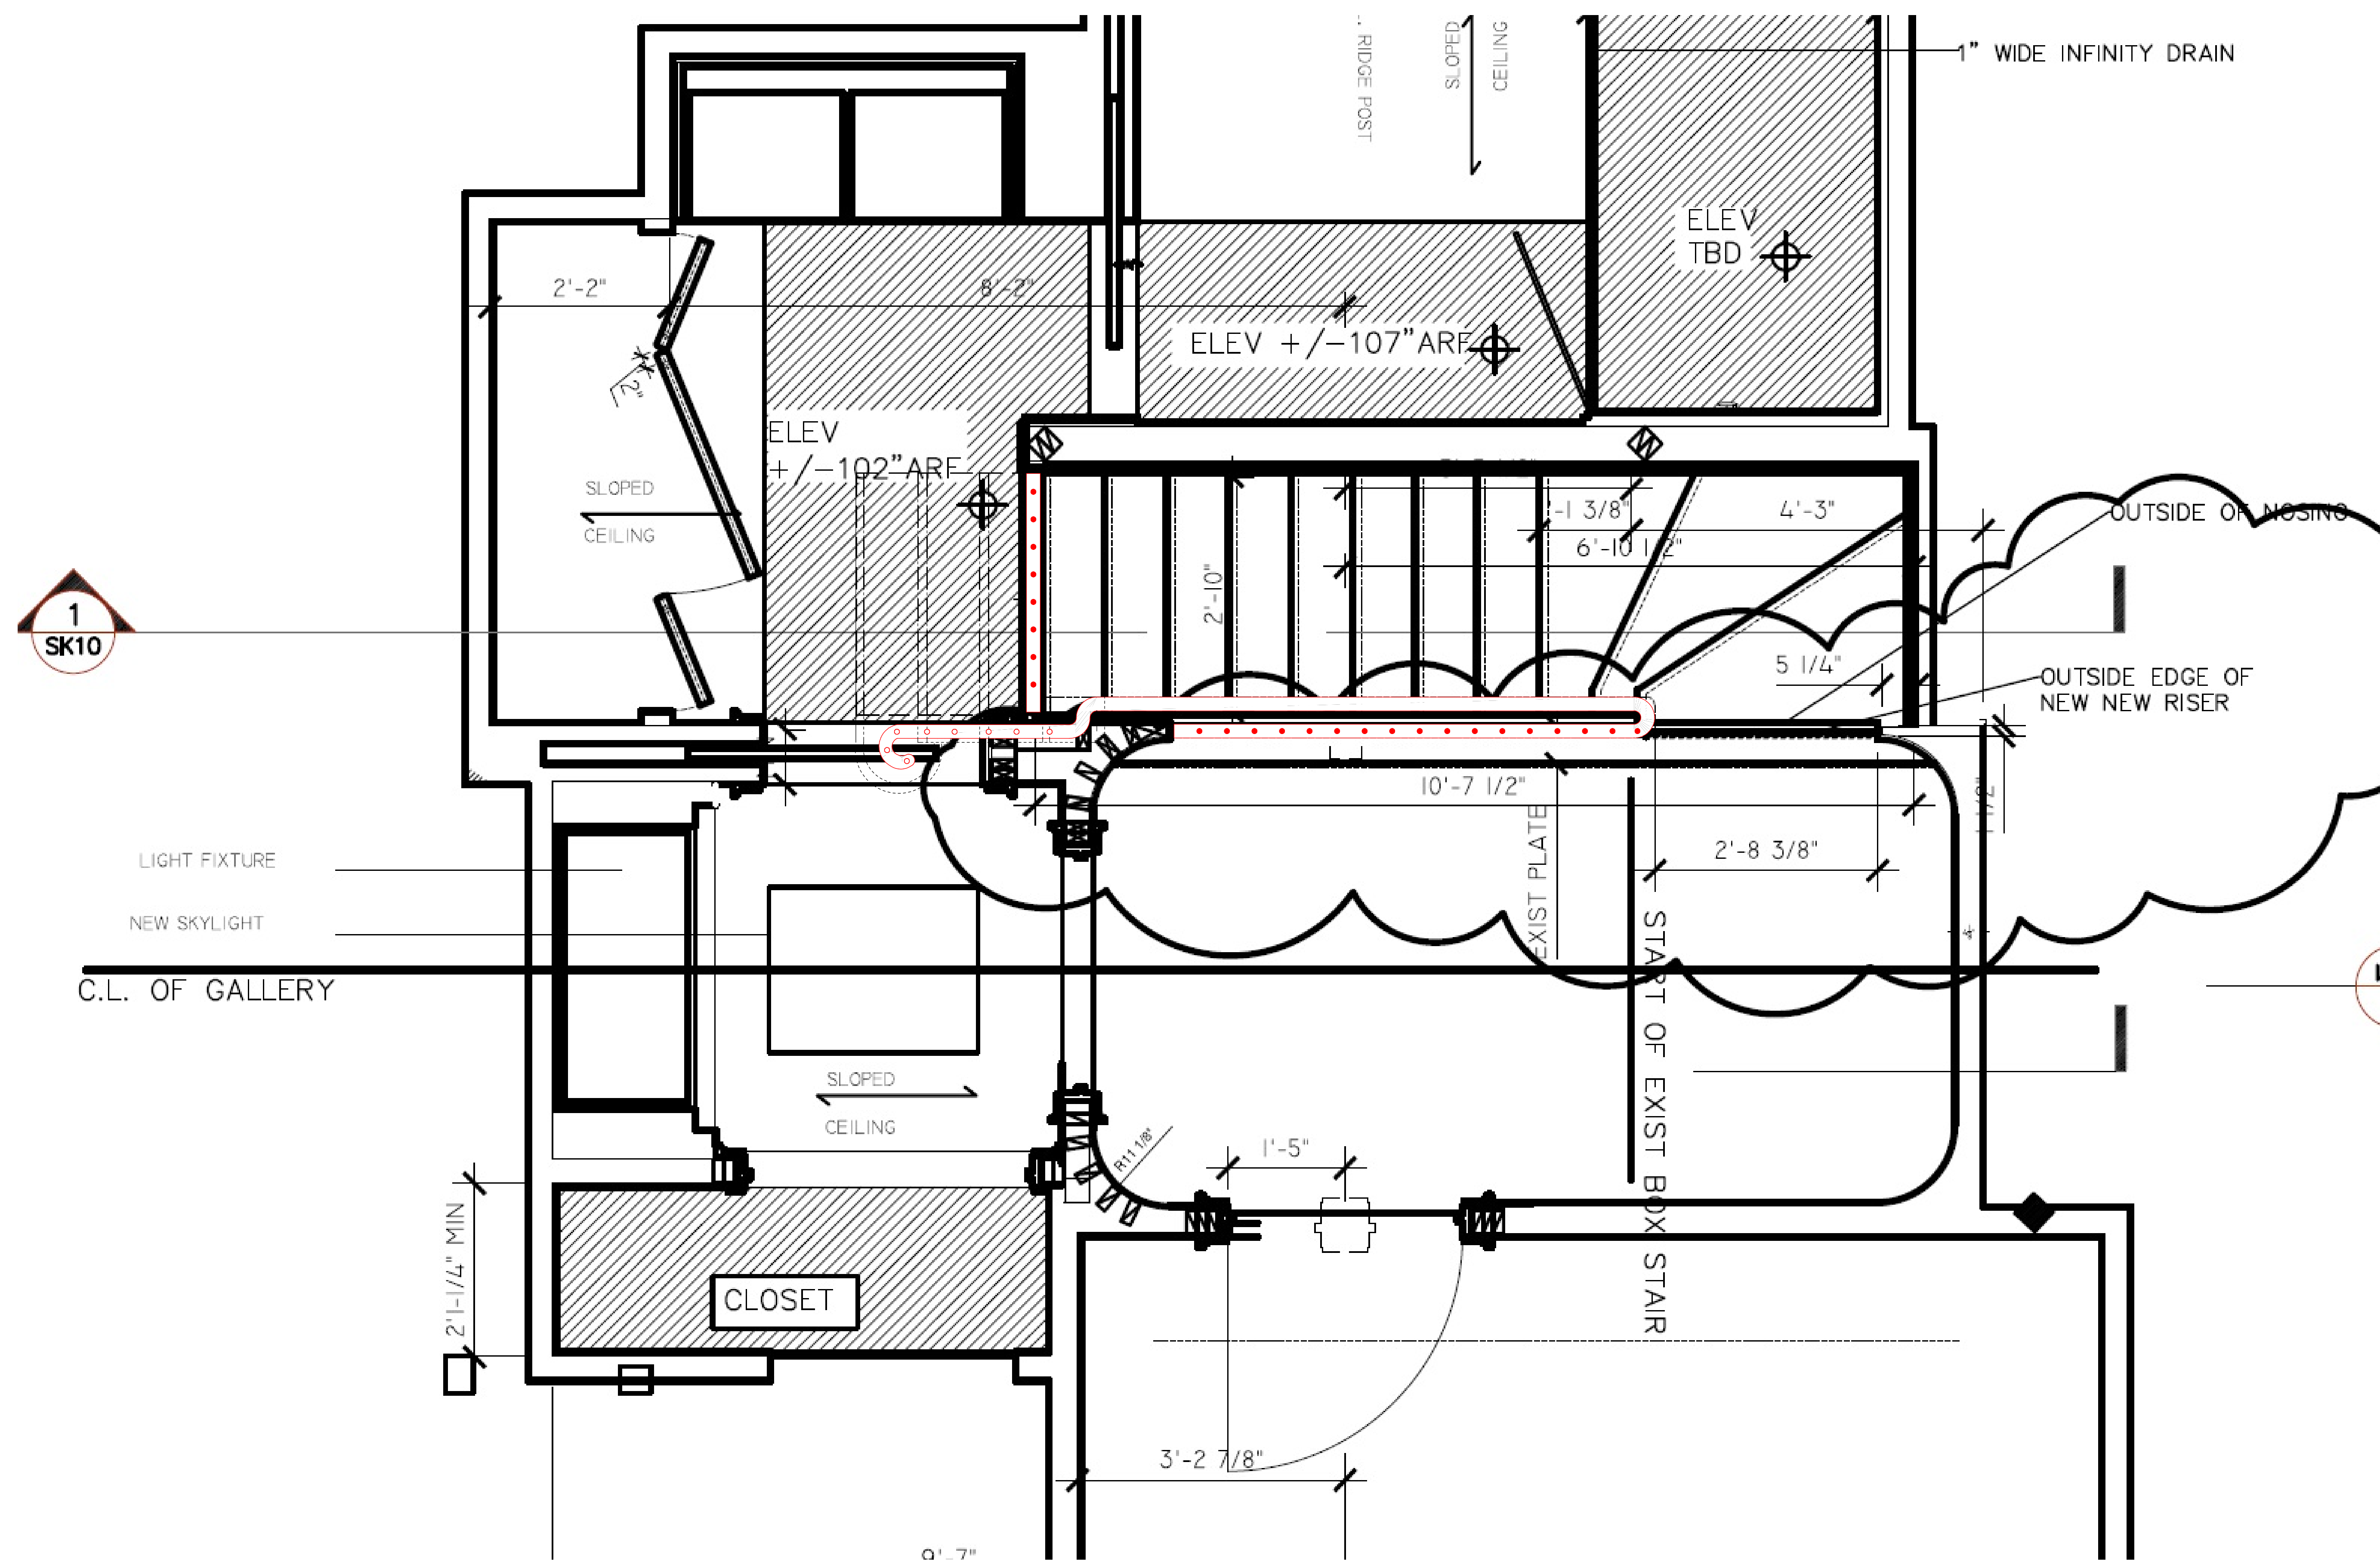

Railing Plan (Overlaid on drawing by Paul Regan, Architect)

Scale: 1" = 1'

REVISION TABLE	
NUMBER	DATE

Webb Builders, Inc.
Design and Construction
www.dwebb-site.com


Mill's Renovation
Shop Drawings

Railing Plan

DATE:
11/30/2015

SCALE:

SHEET:

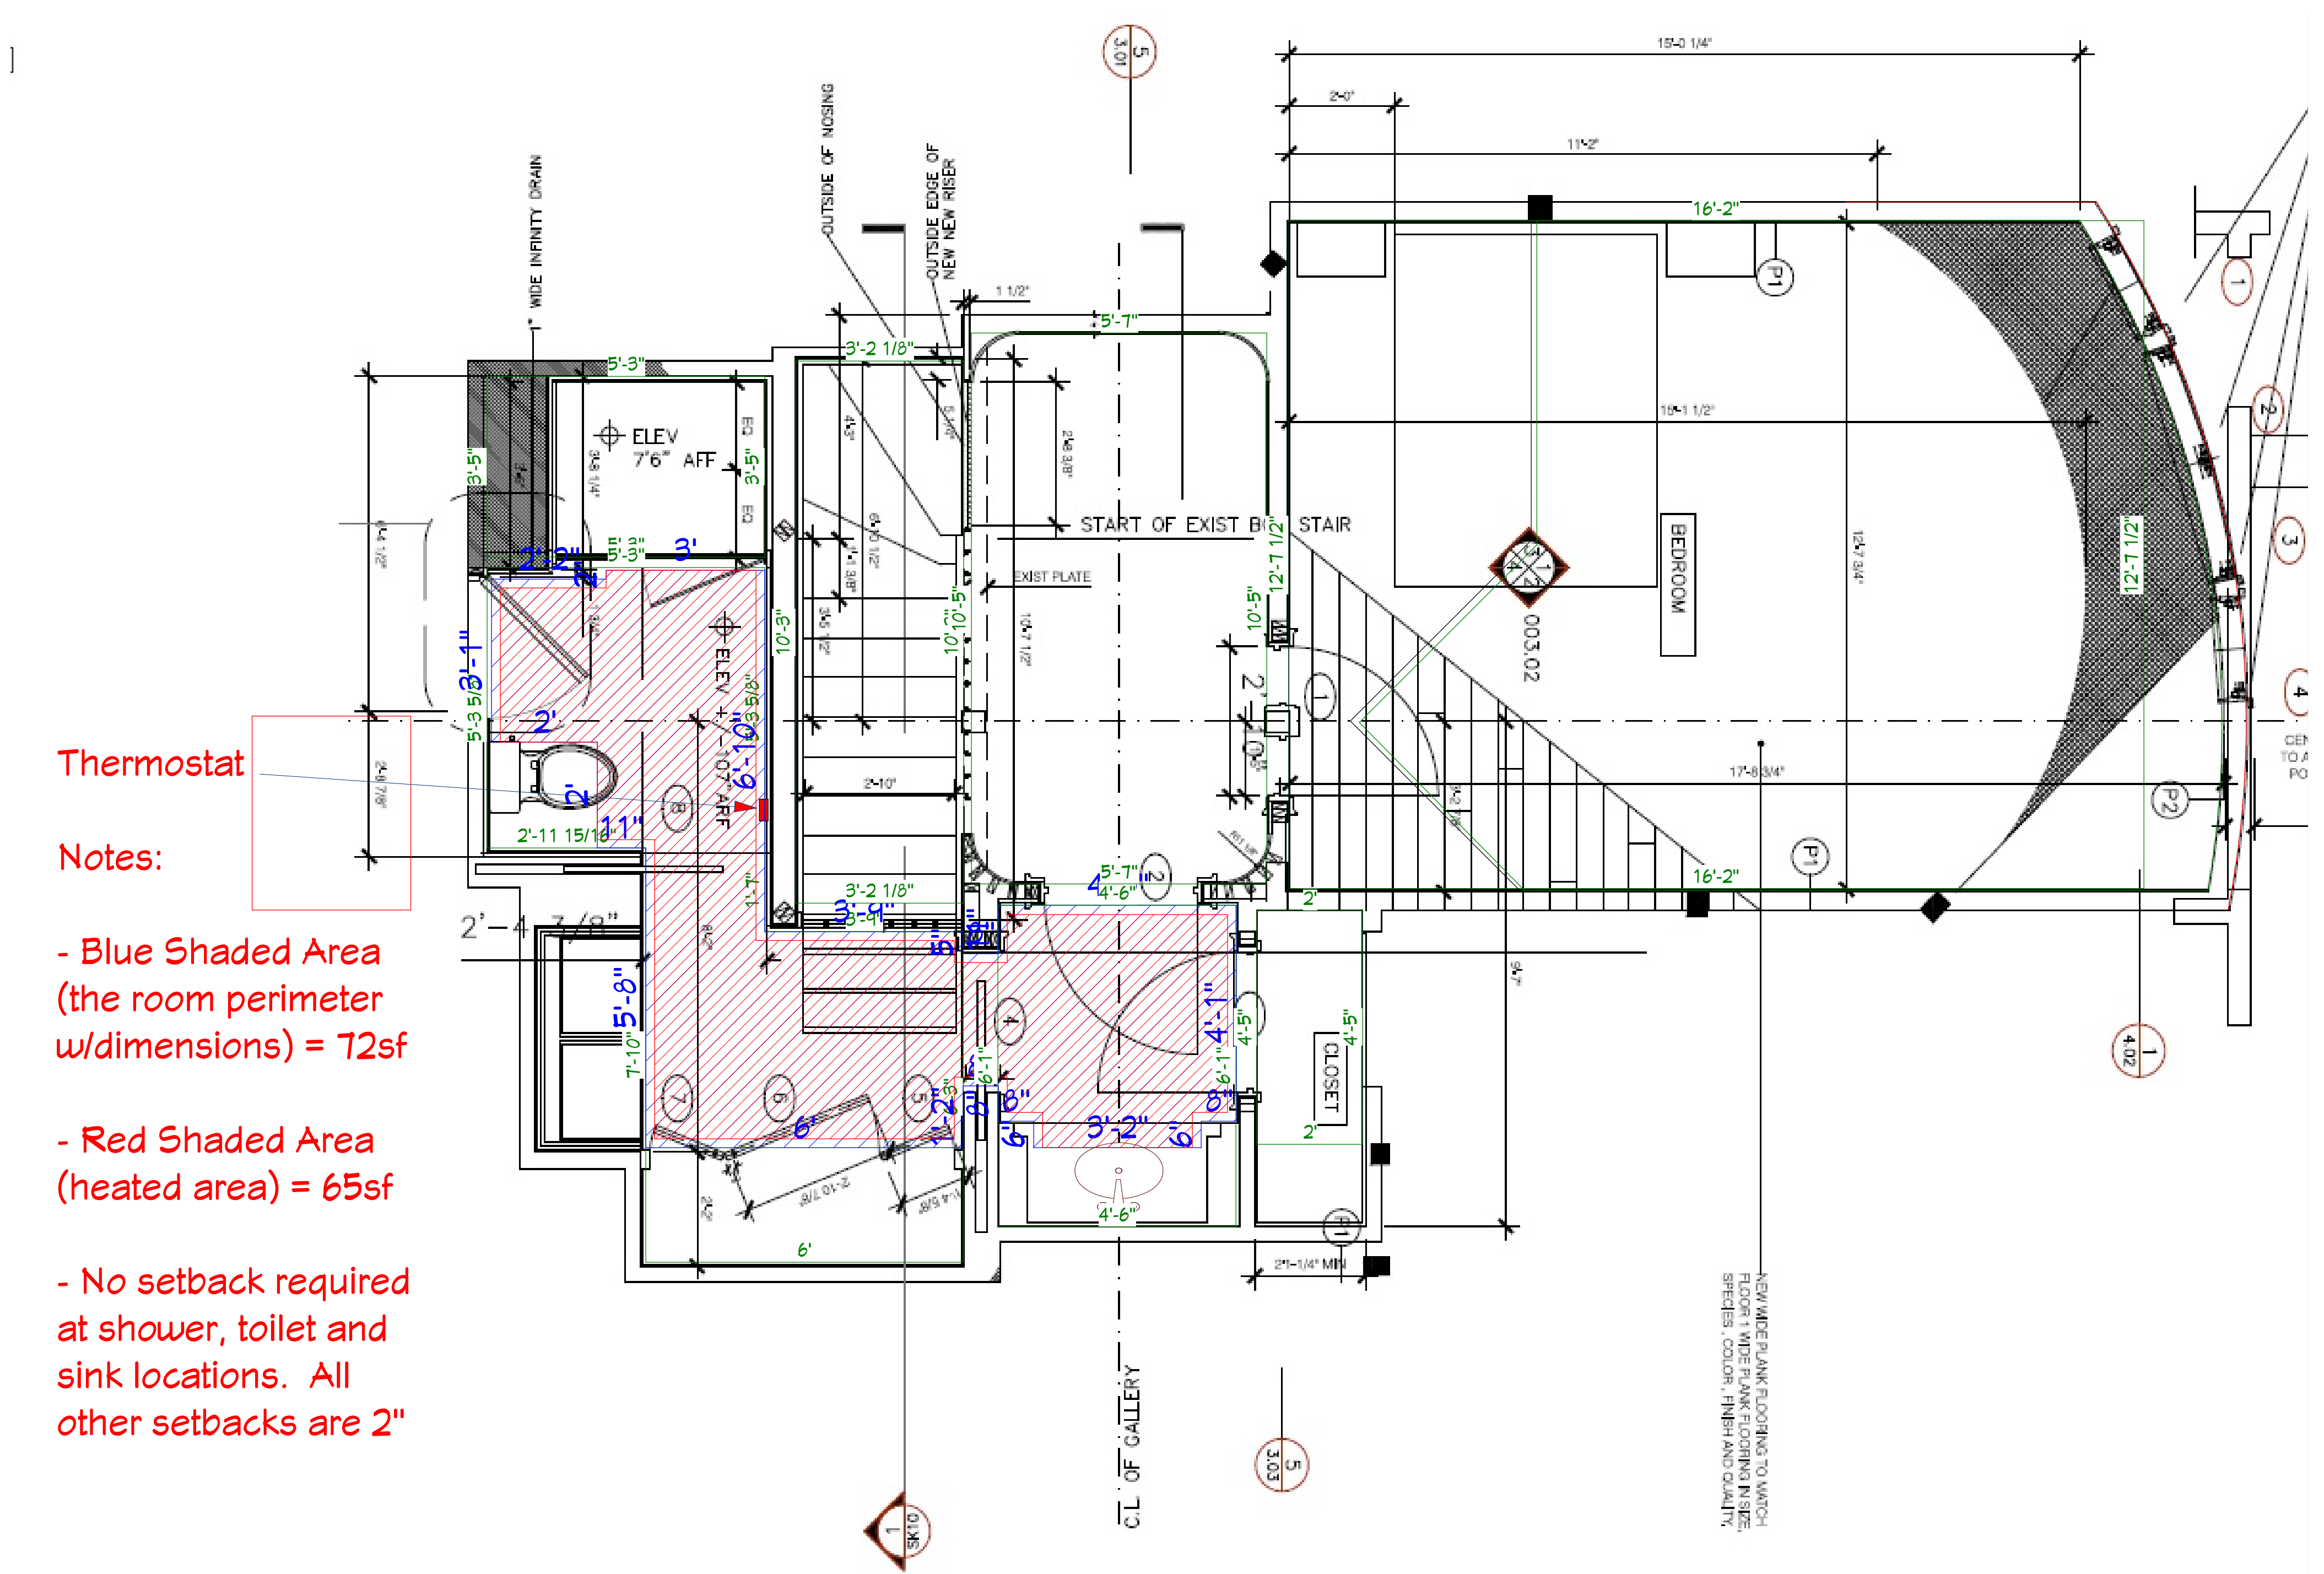

Thermostat

Notes:

- Blue Shaded Area (the room perimeter w/dimensions) = 72sf
- Red Shaded Area (heated area) = 65sf
- No setback required at shower, toilet and sink locations. All other setbacks are 2"

Radiant Heat Area (floor plan by Paul Regan Architect) Scale: 1/2" = 1'

REVISION TABLE	
NUMBER	DATE

Webb Builders, Inc.
Design and Construction
www.dwebbiste.com


Mill's Renovation
Shop Drawings

Radiant Heat Plan


DATE: 11/30/2015

SCALE:

SHEET: 7

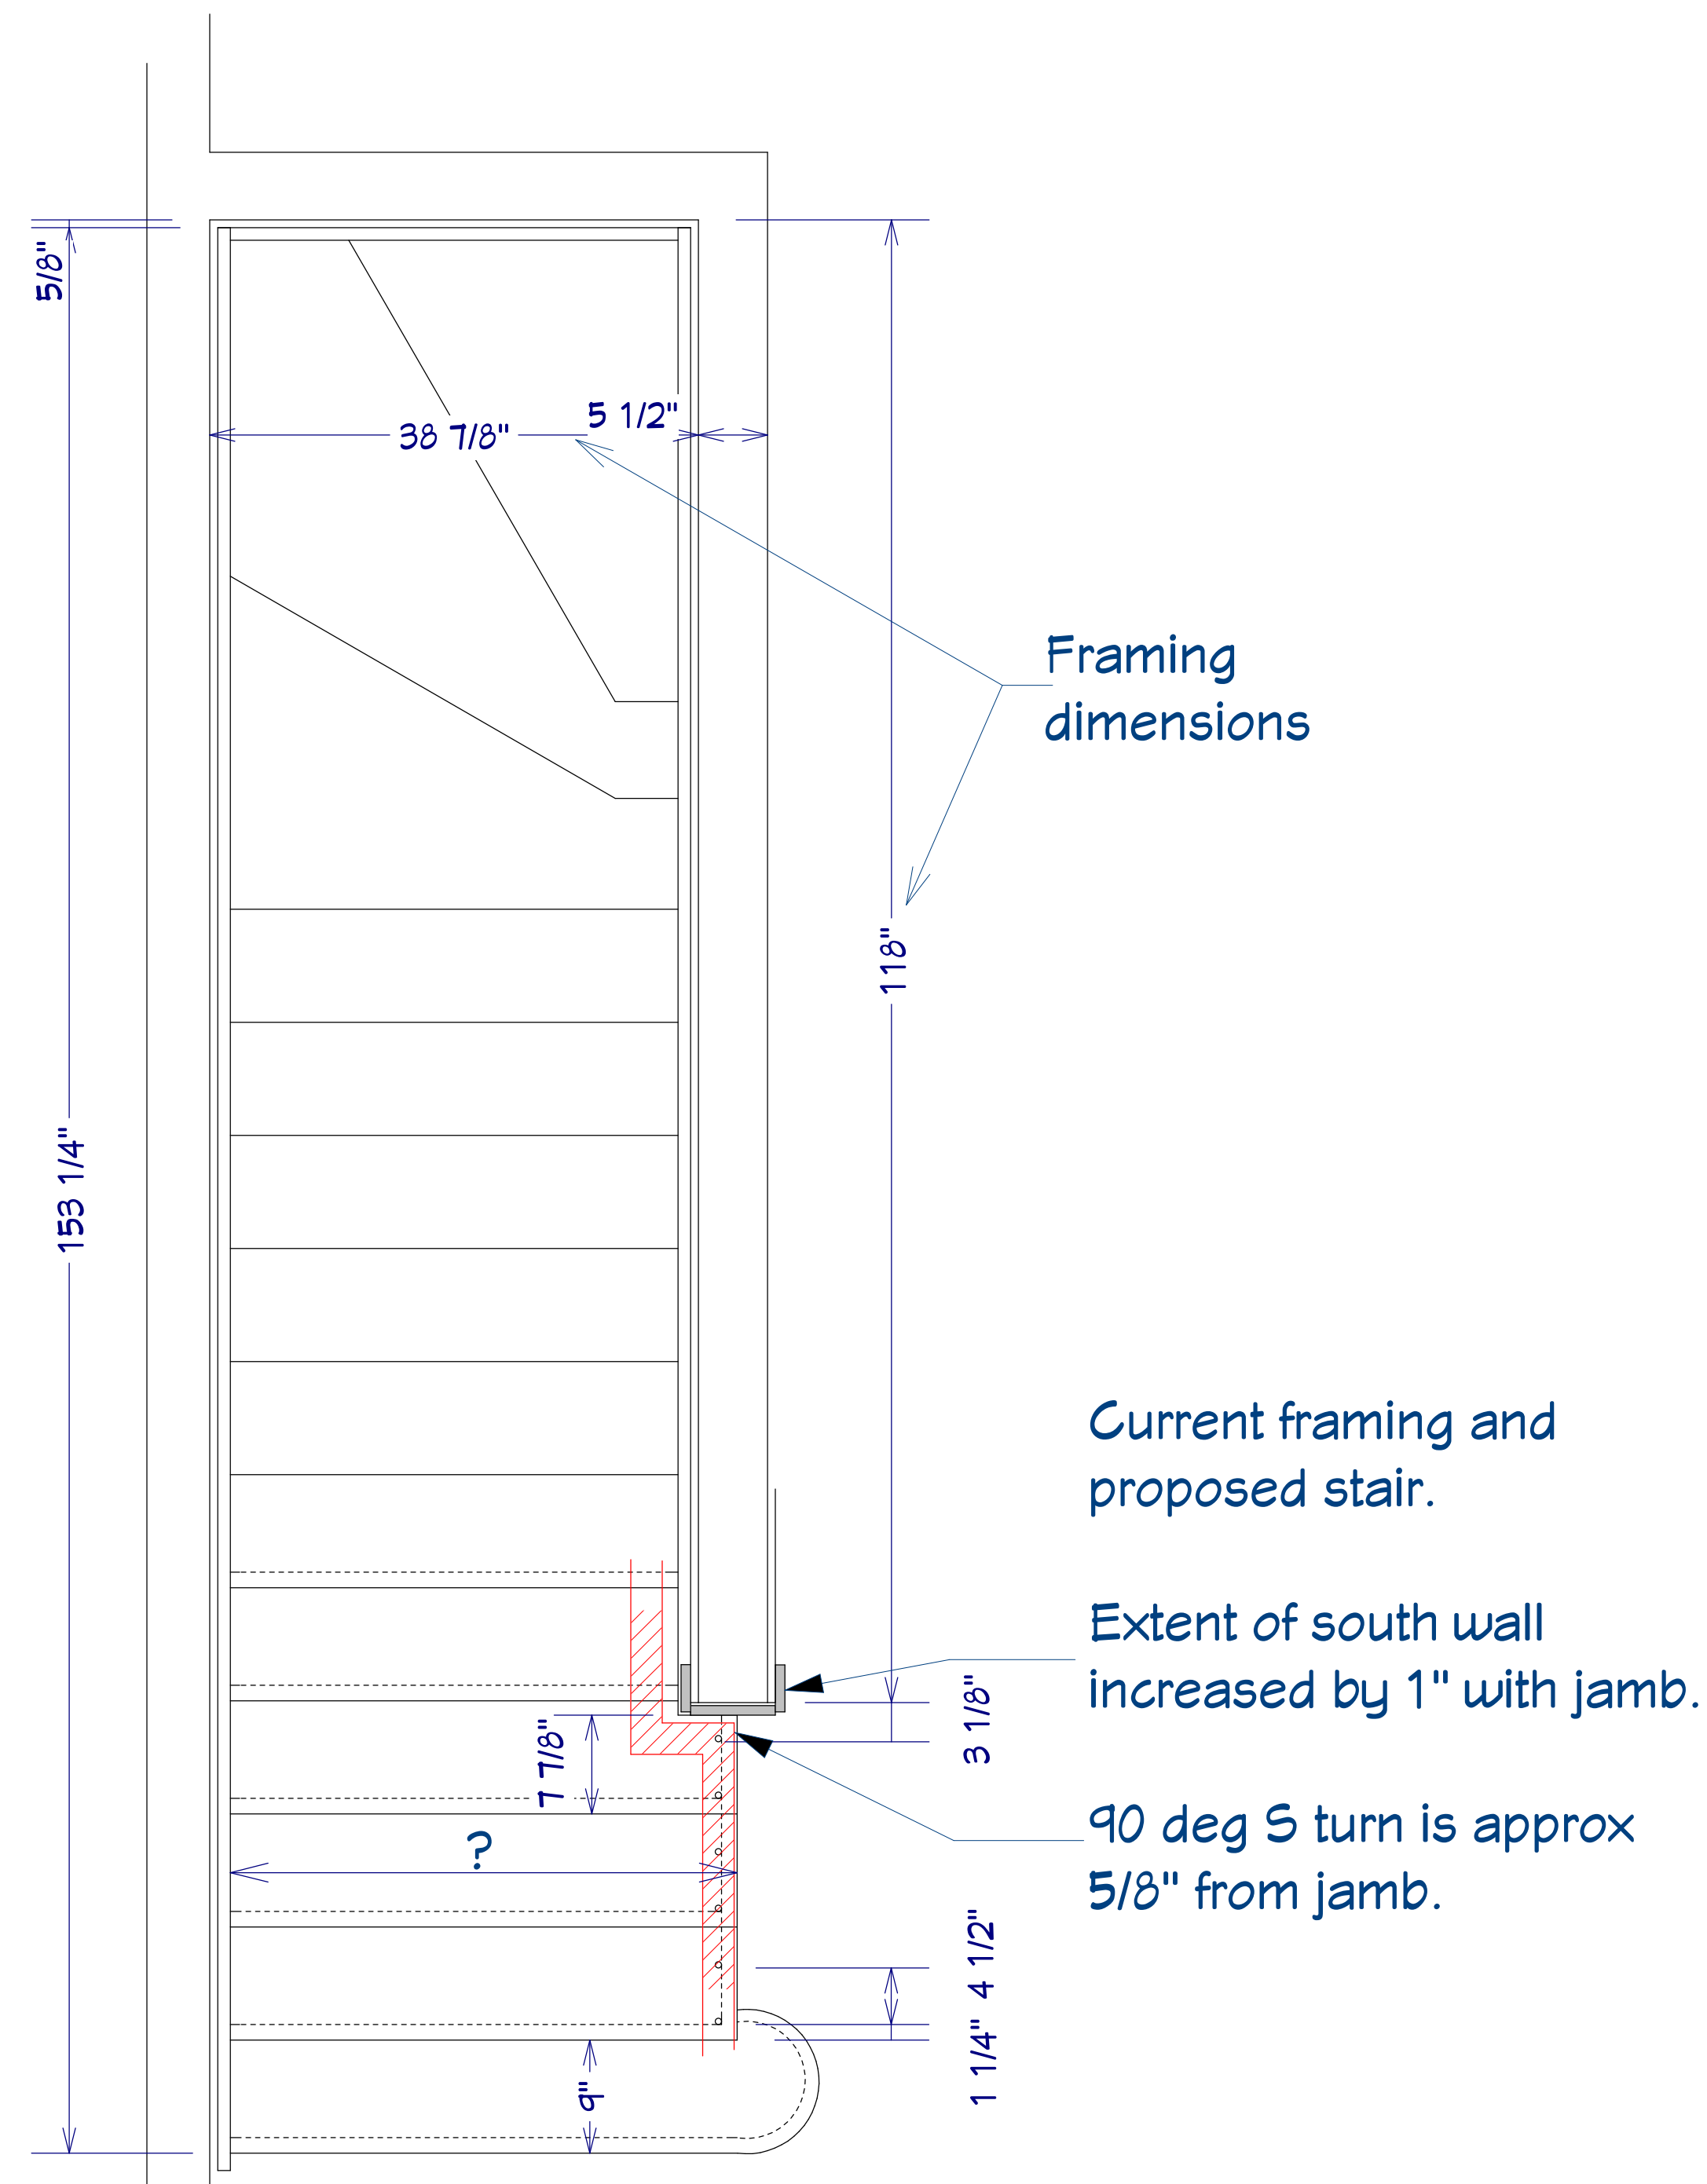

Tread notch and S turn detail

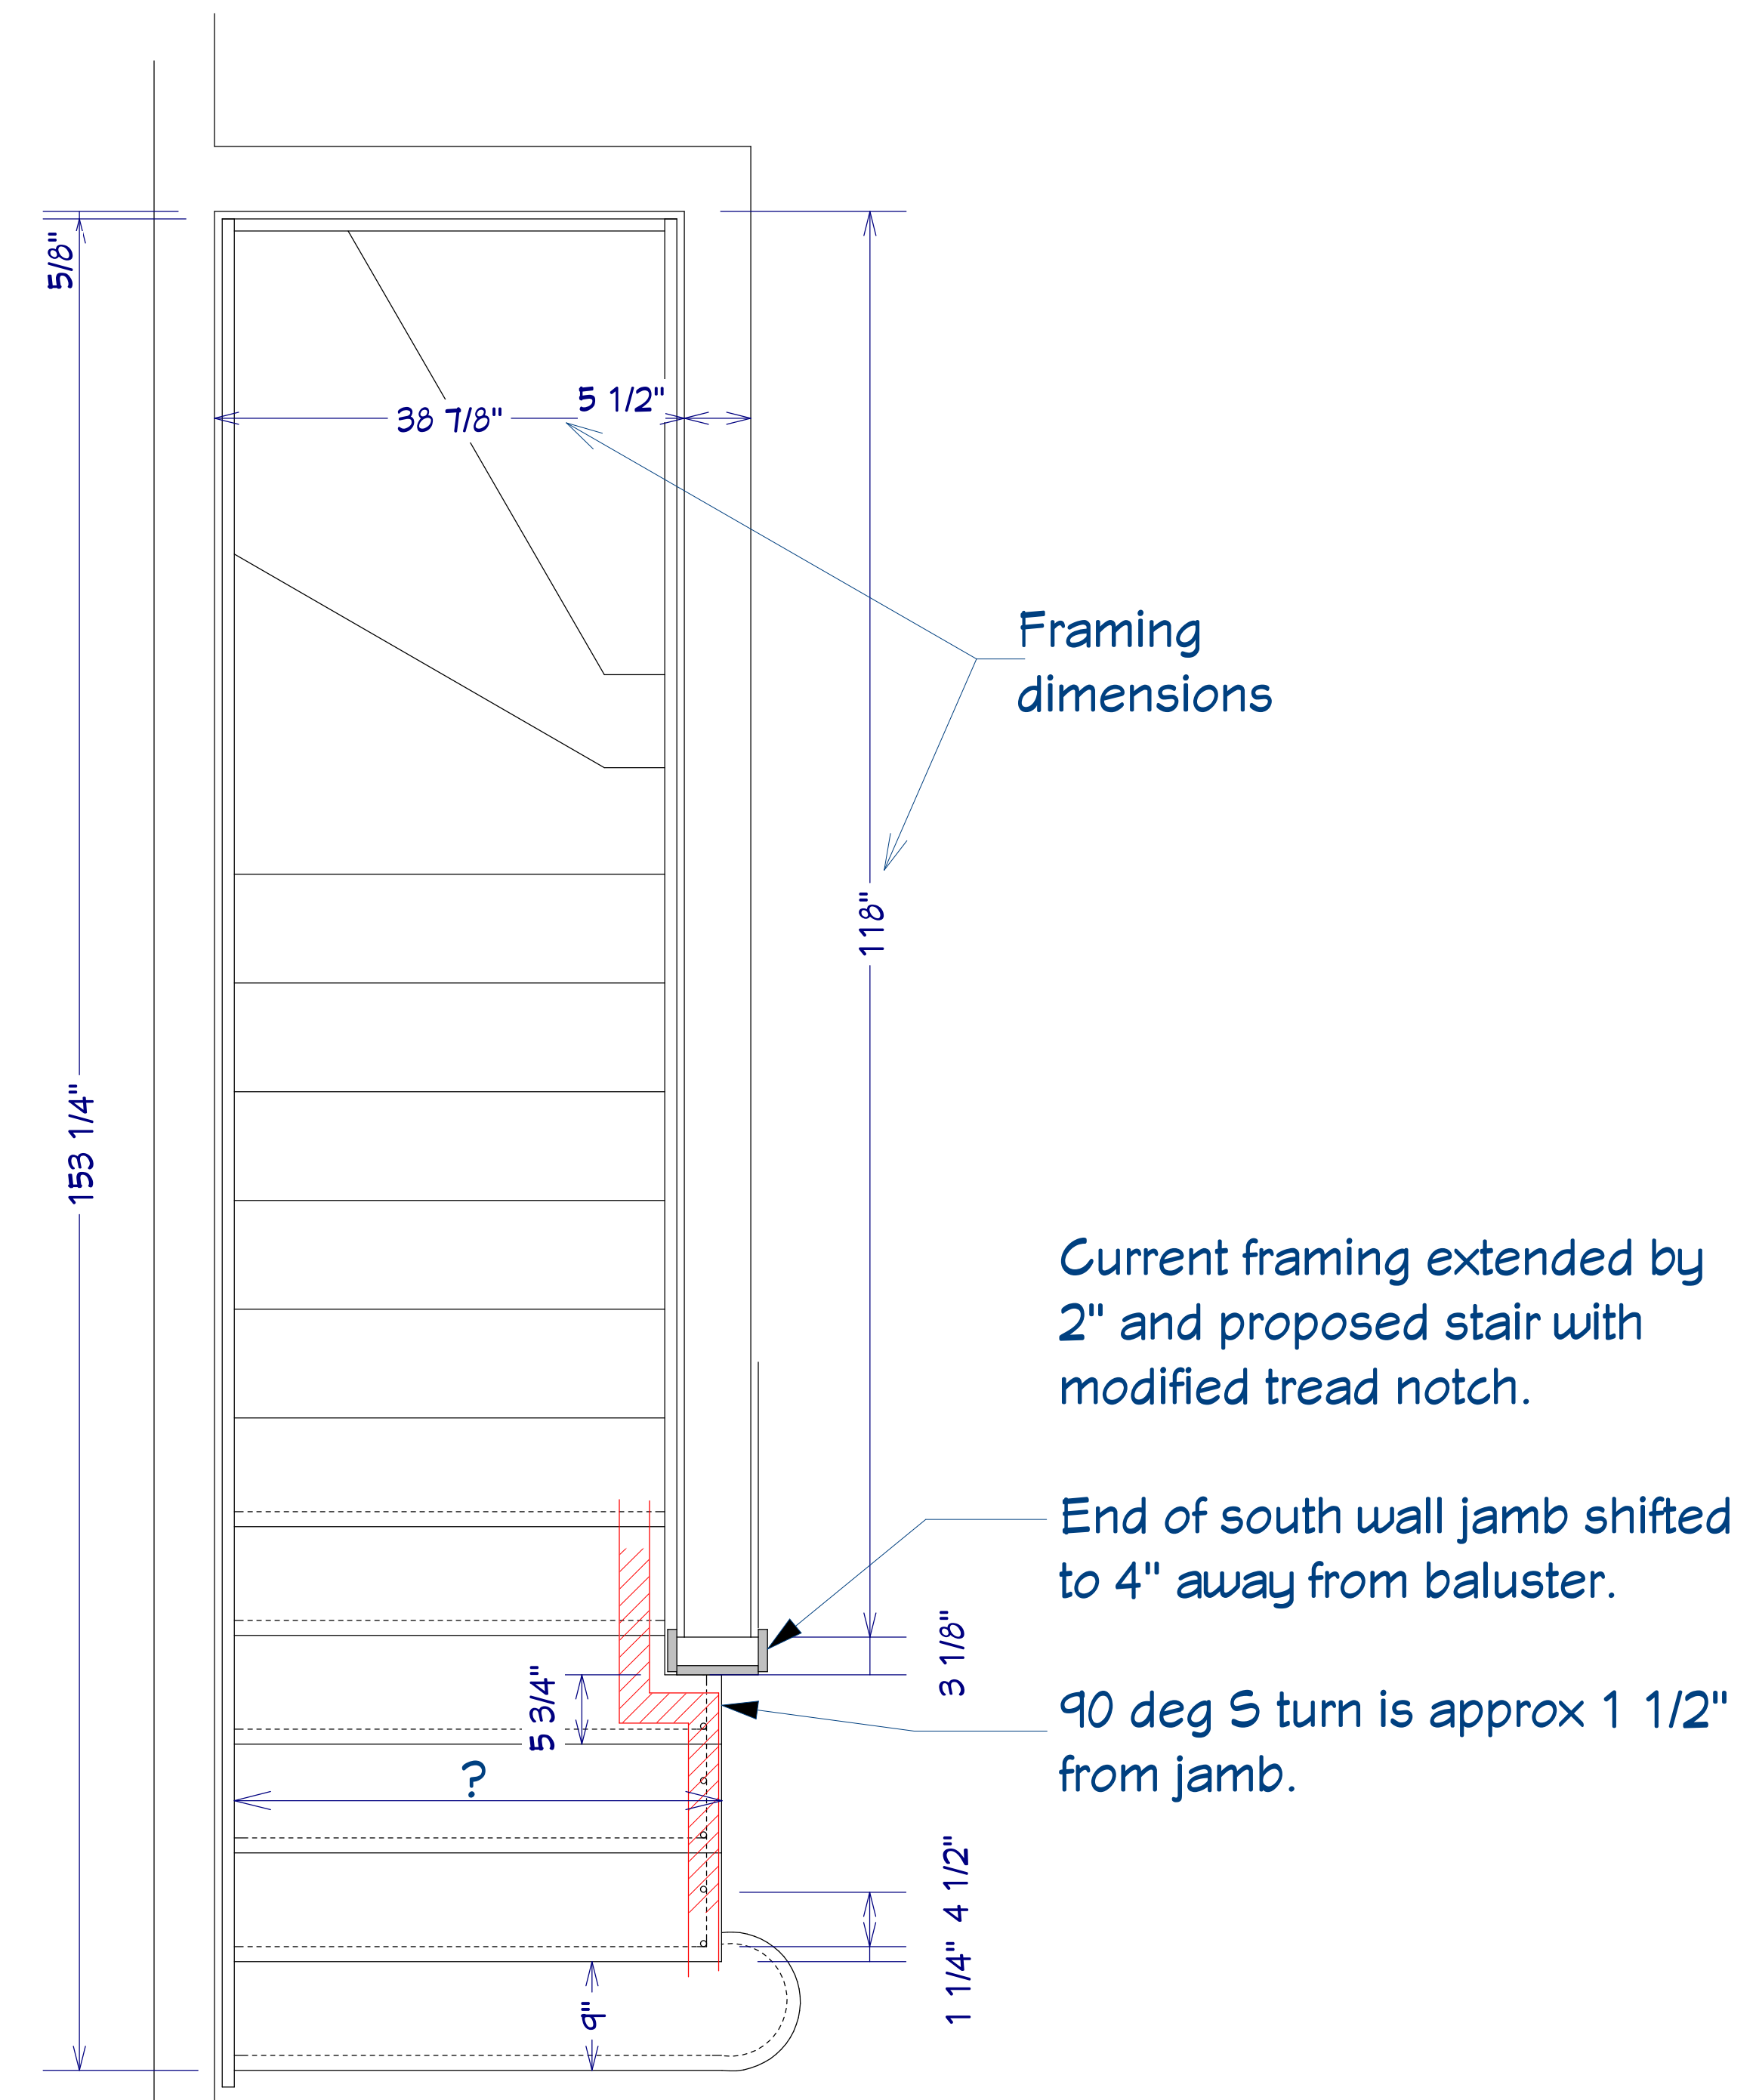

Scale: 1" = 1'

REVISION TABLE		NUMBER	DATE	REVISOR	DESCRIPTION

Webb Builders, Inc.
Design and Construction
www.dwebb-site.com

Mill's Renovation
Shop Drawings

Stair and Rail Details


DATE:

11/30/2015

SCALE:


SHEET:

8

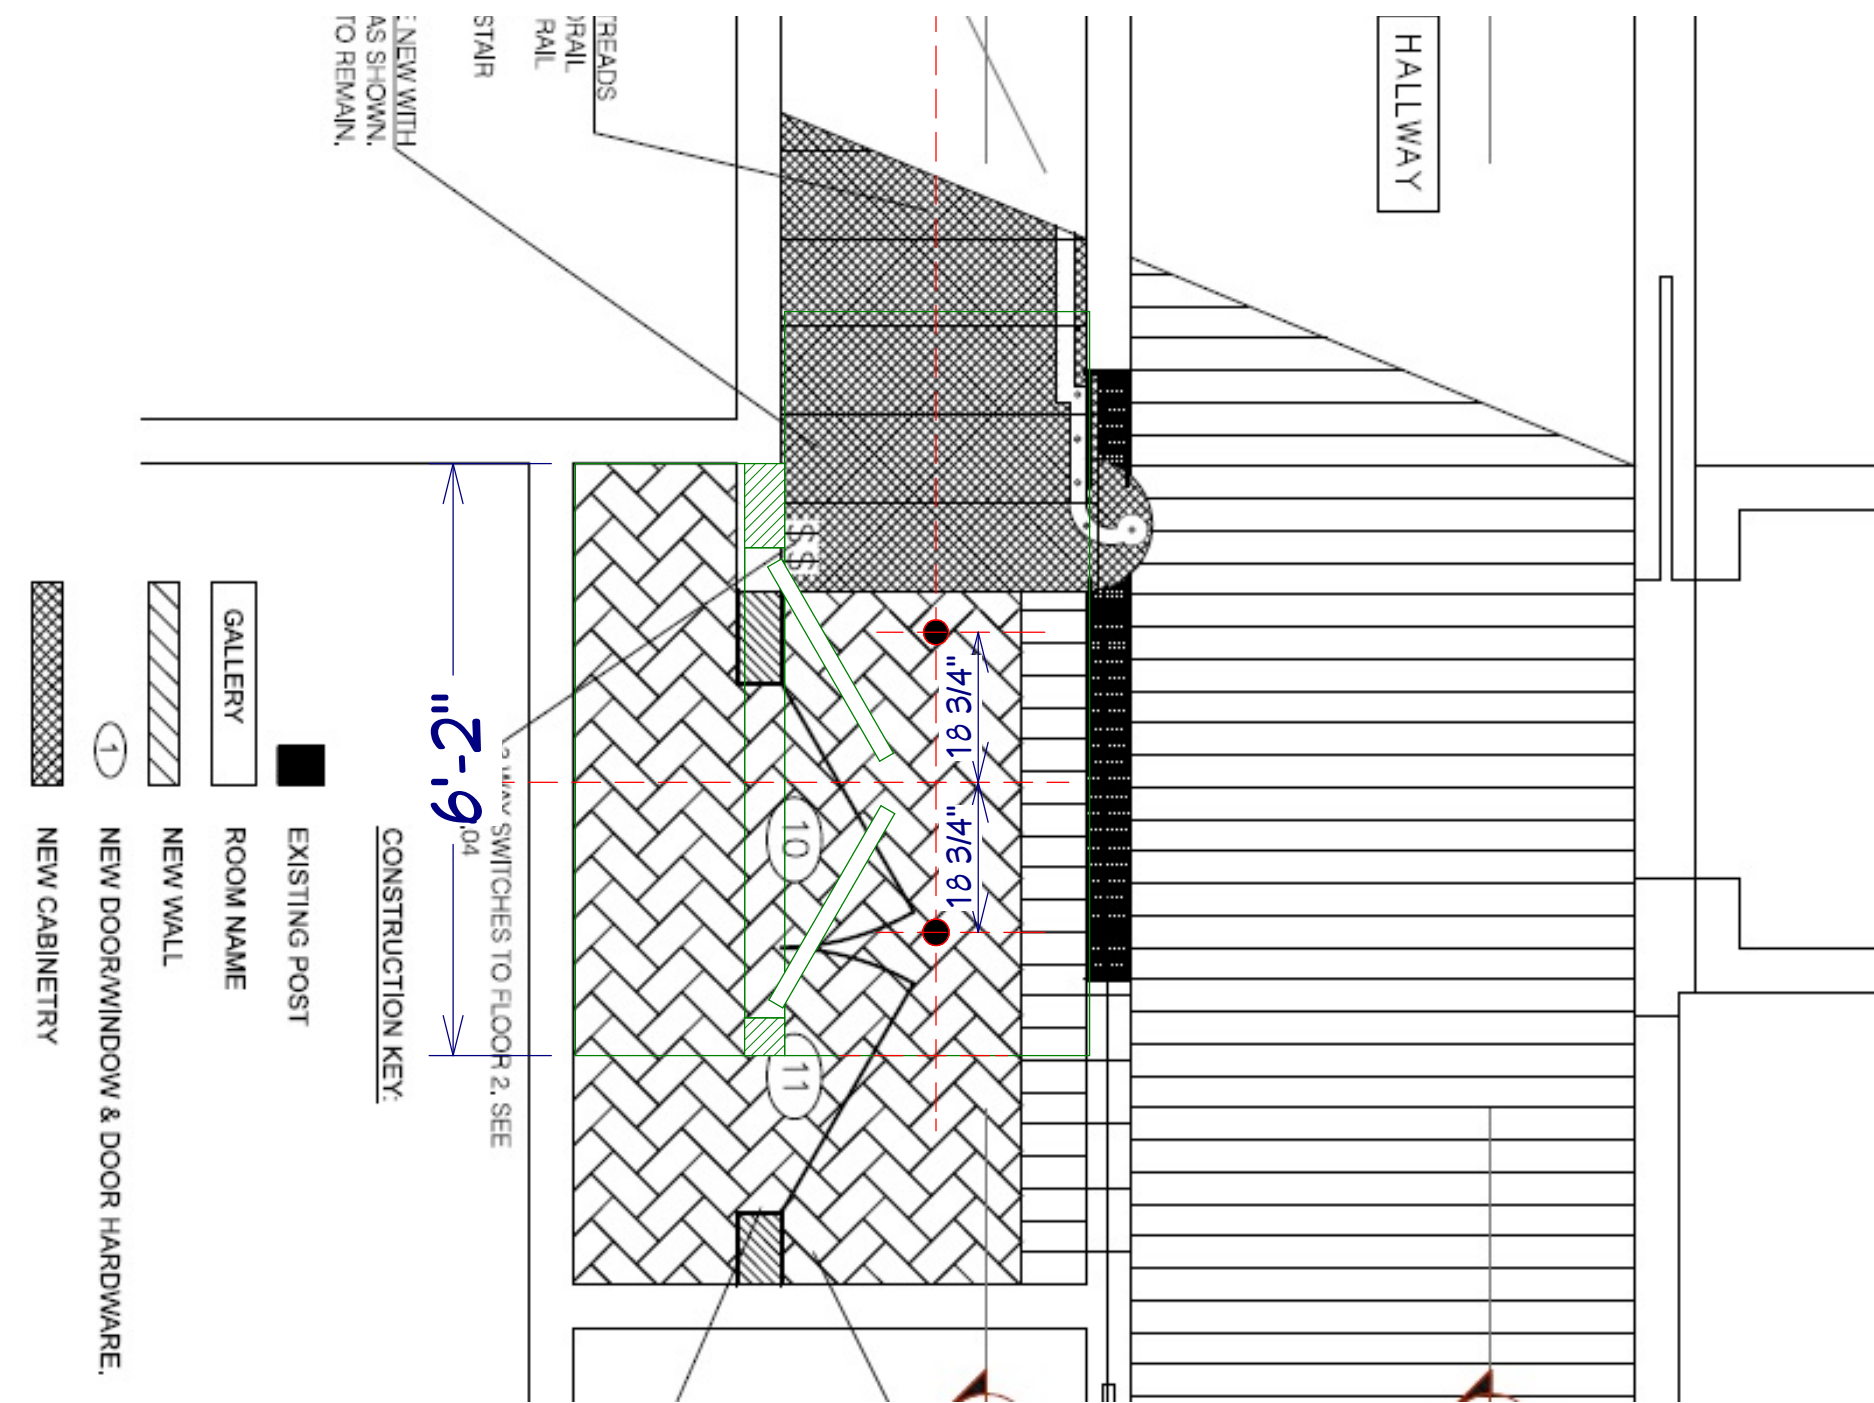

Lighting Plan at (resized) coat closet

Scale: 1/2" = 1'

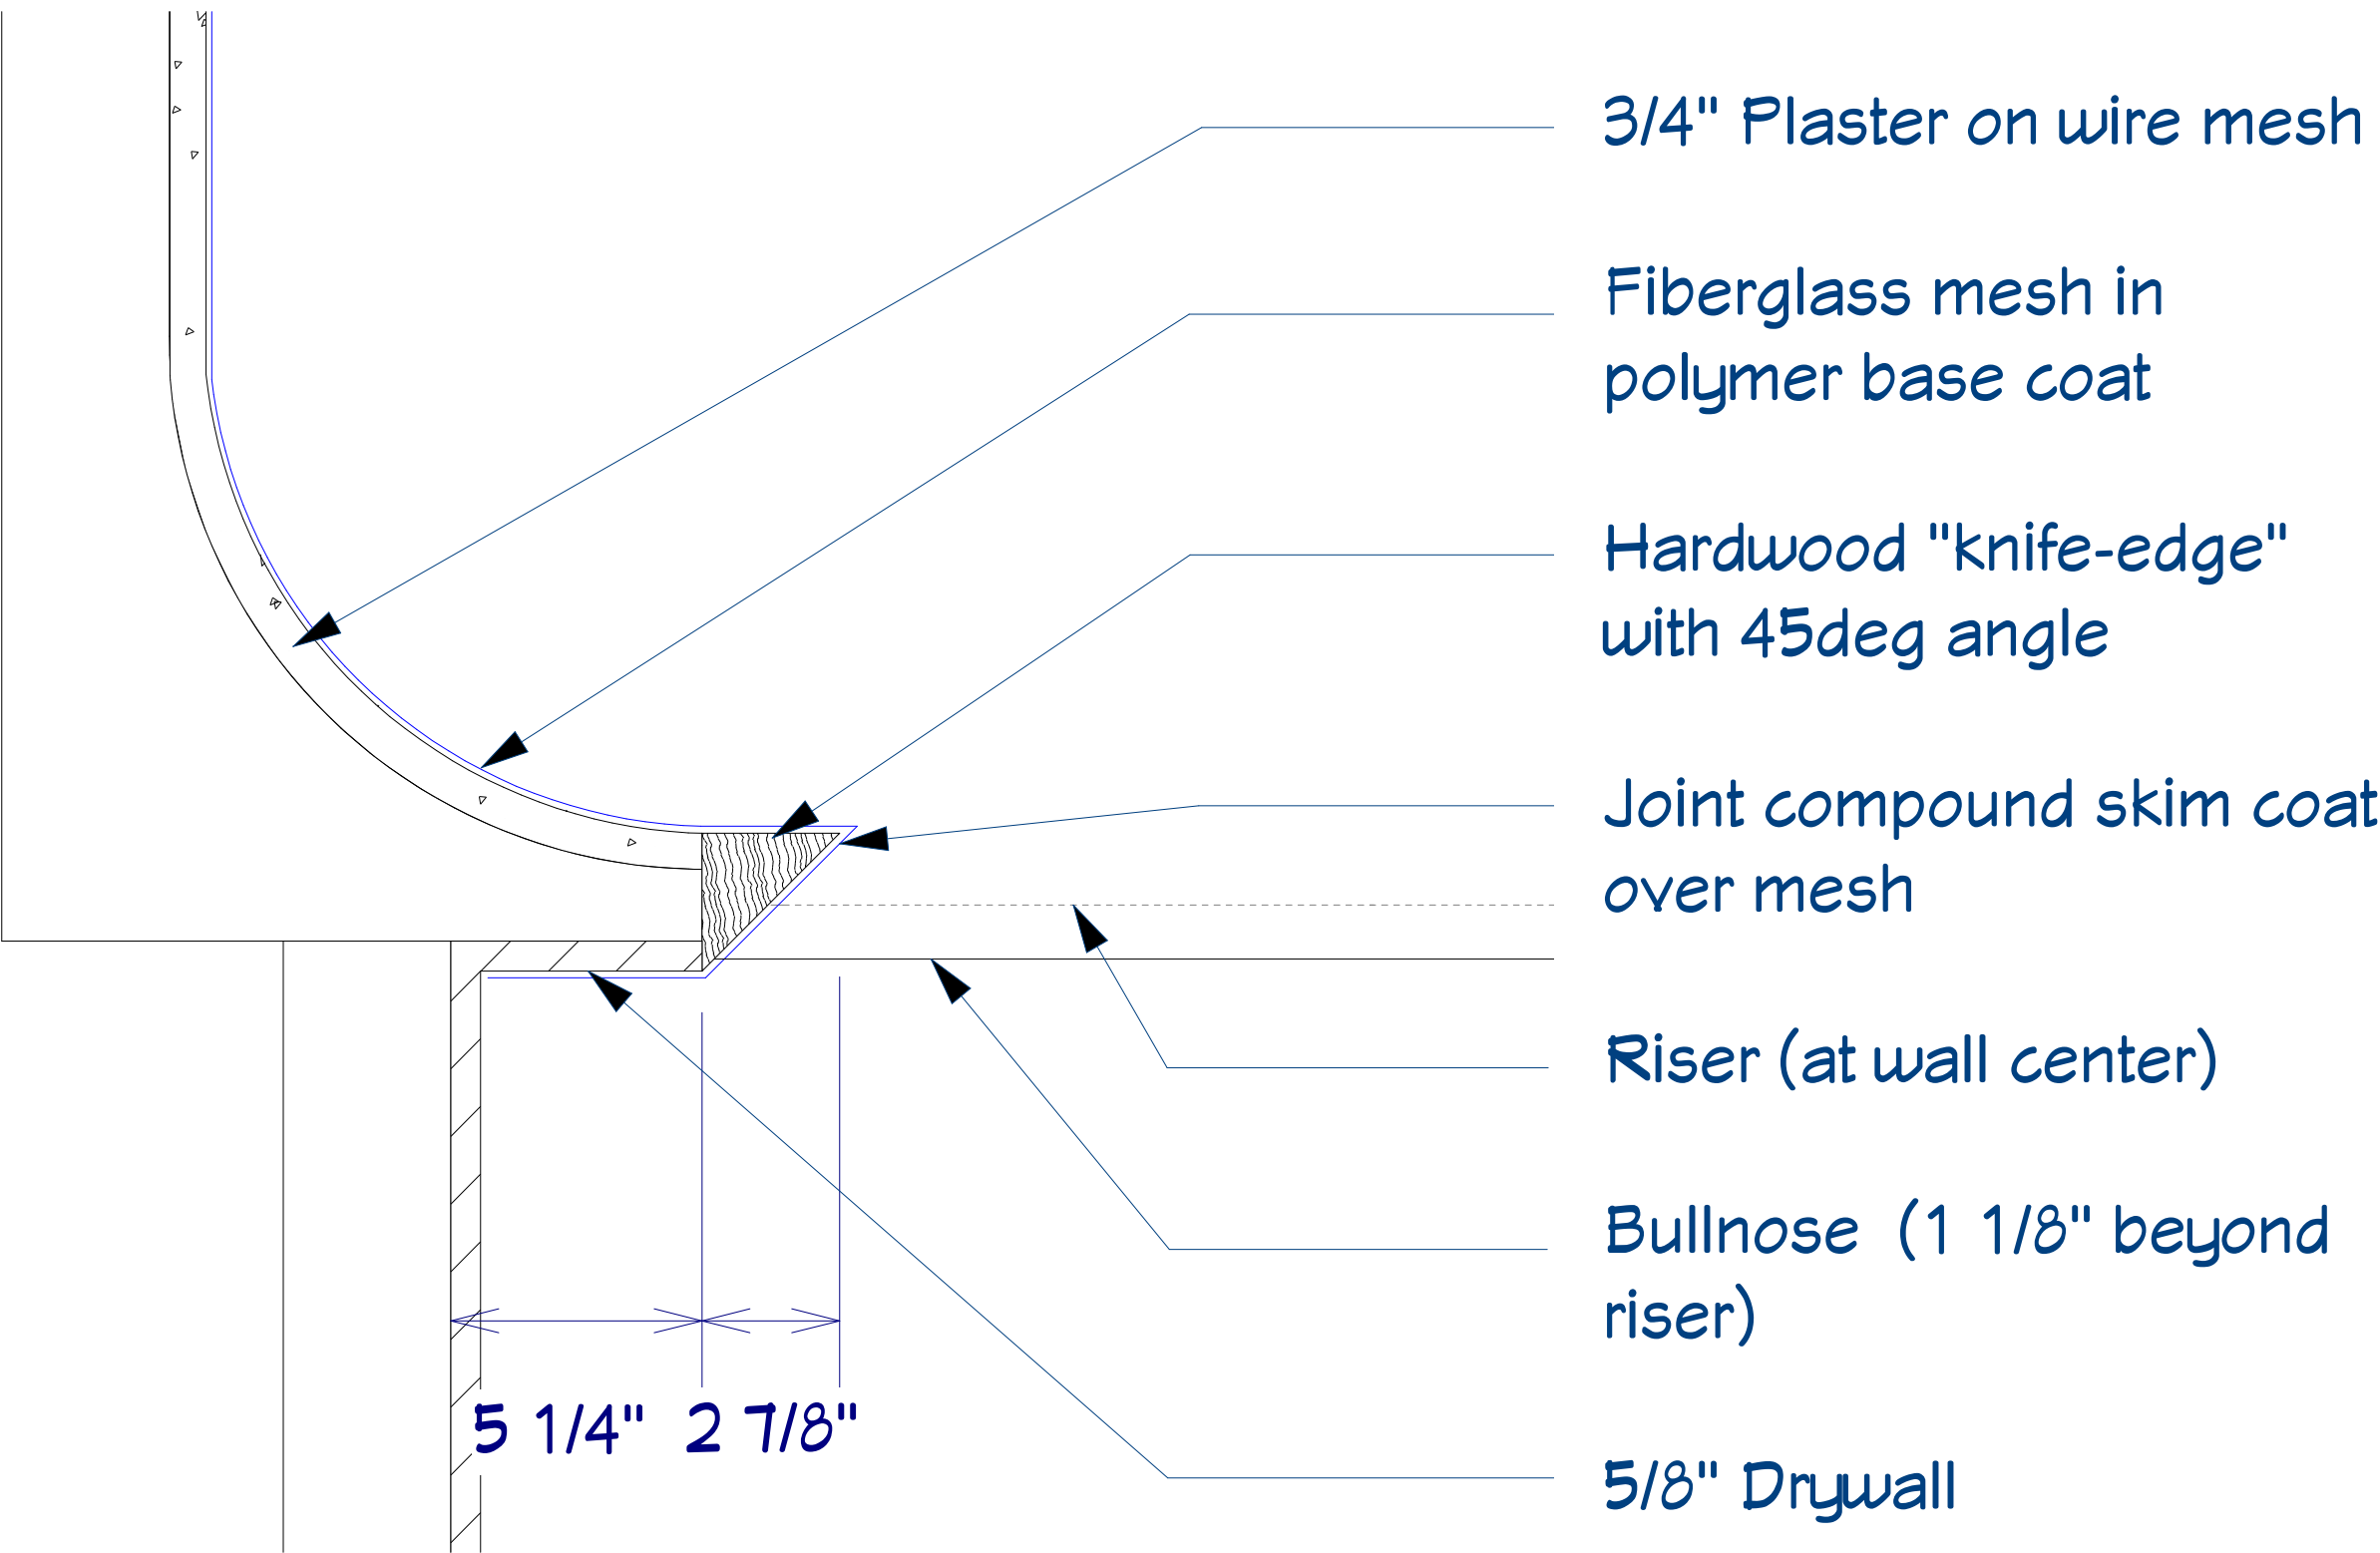

Plan Detail at Top of Stair

Scale: 3" = 1'

REVISION TABLE		NUMBER	DATE	REVISION	DESCRIPTION

Webb Builders, Inc.
Design and Construction
www.dwebb-site.com

Mill's Renovation
Shop Drawings

Misc Details

DATE:



11/30/2015

SCALE:

SHEET:

9

A

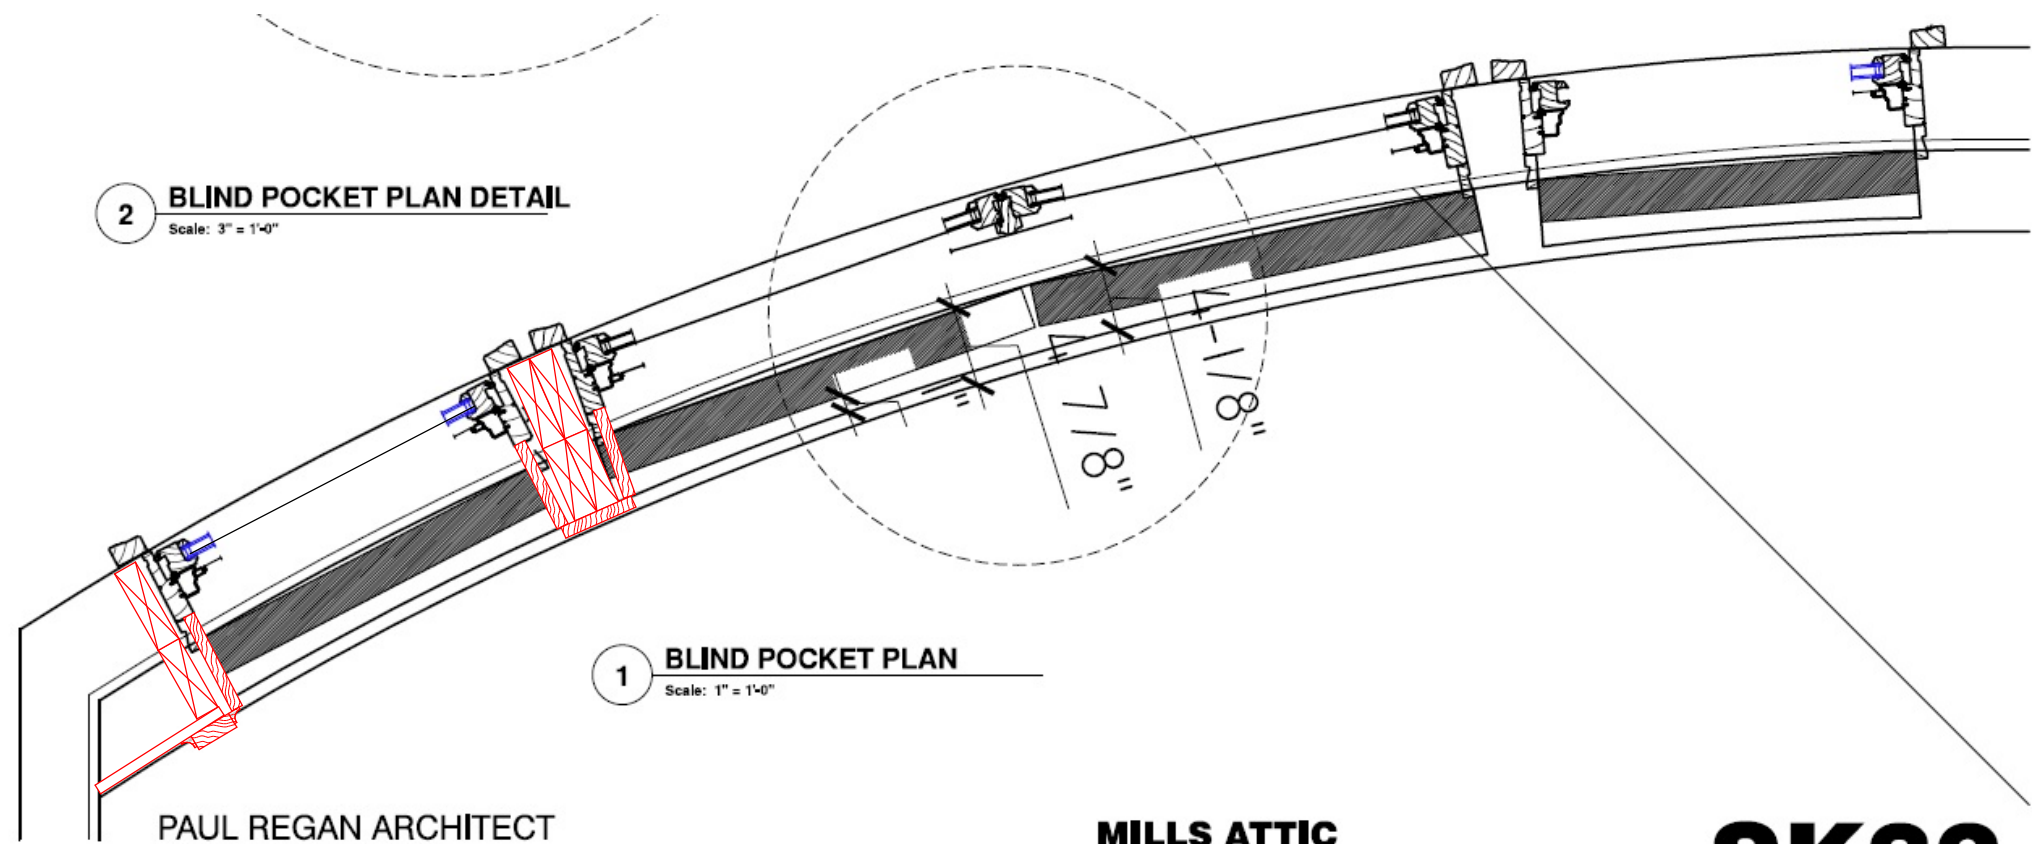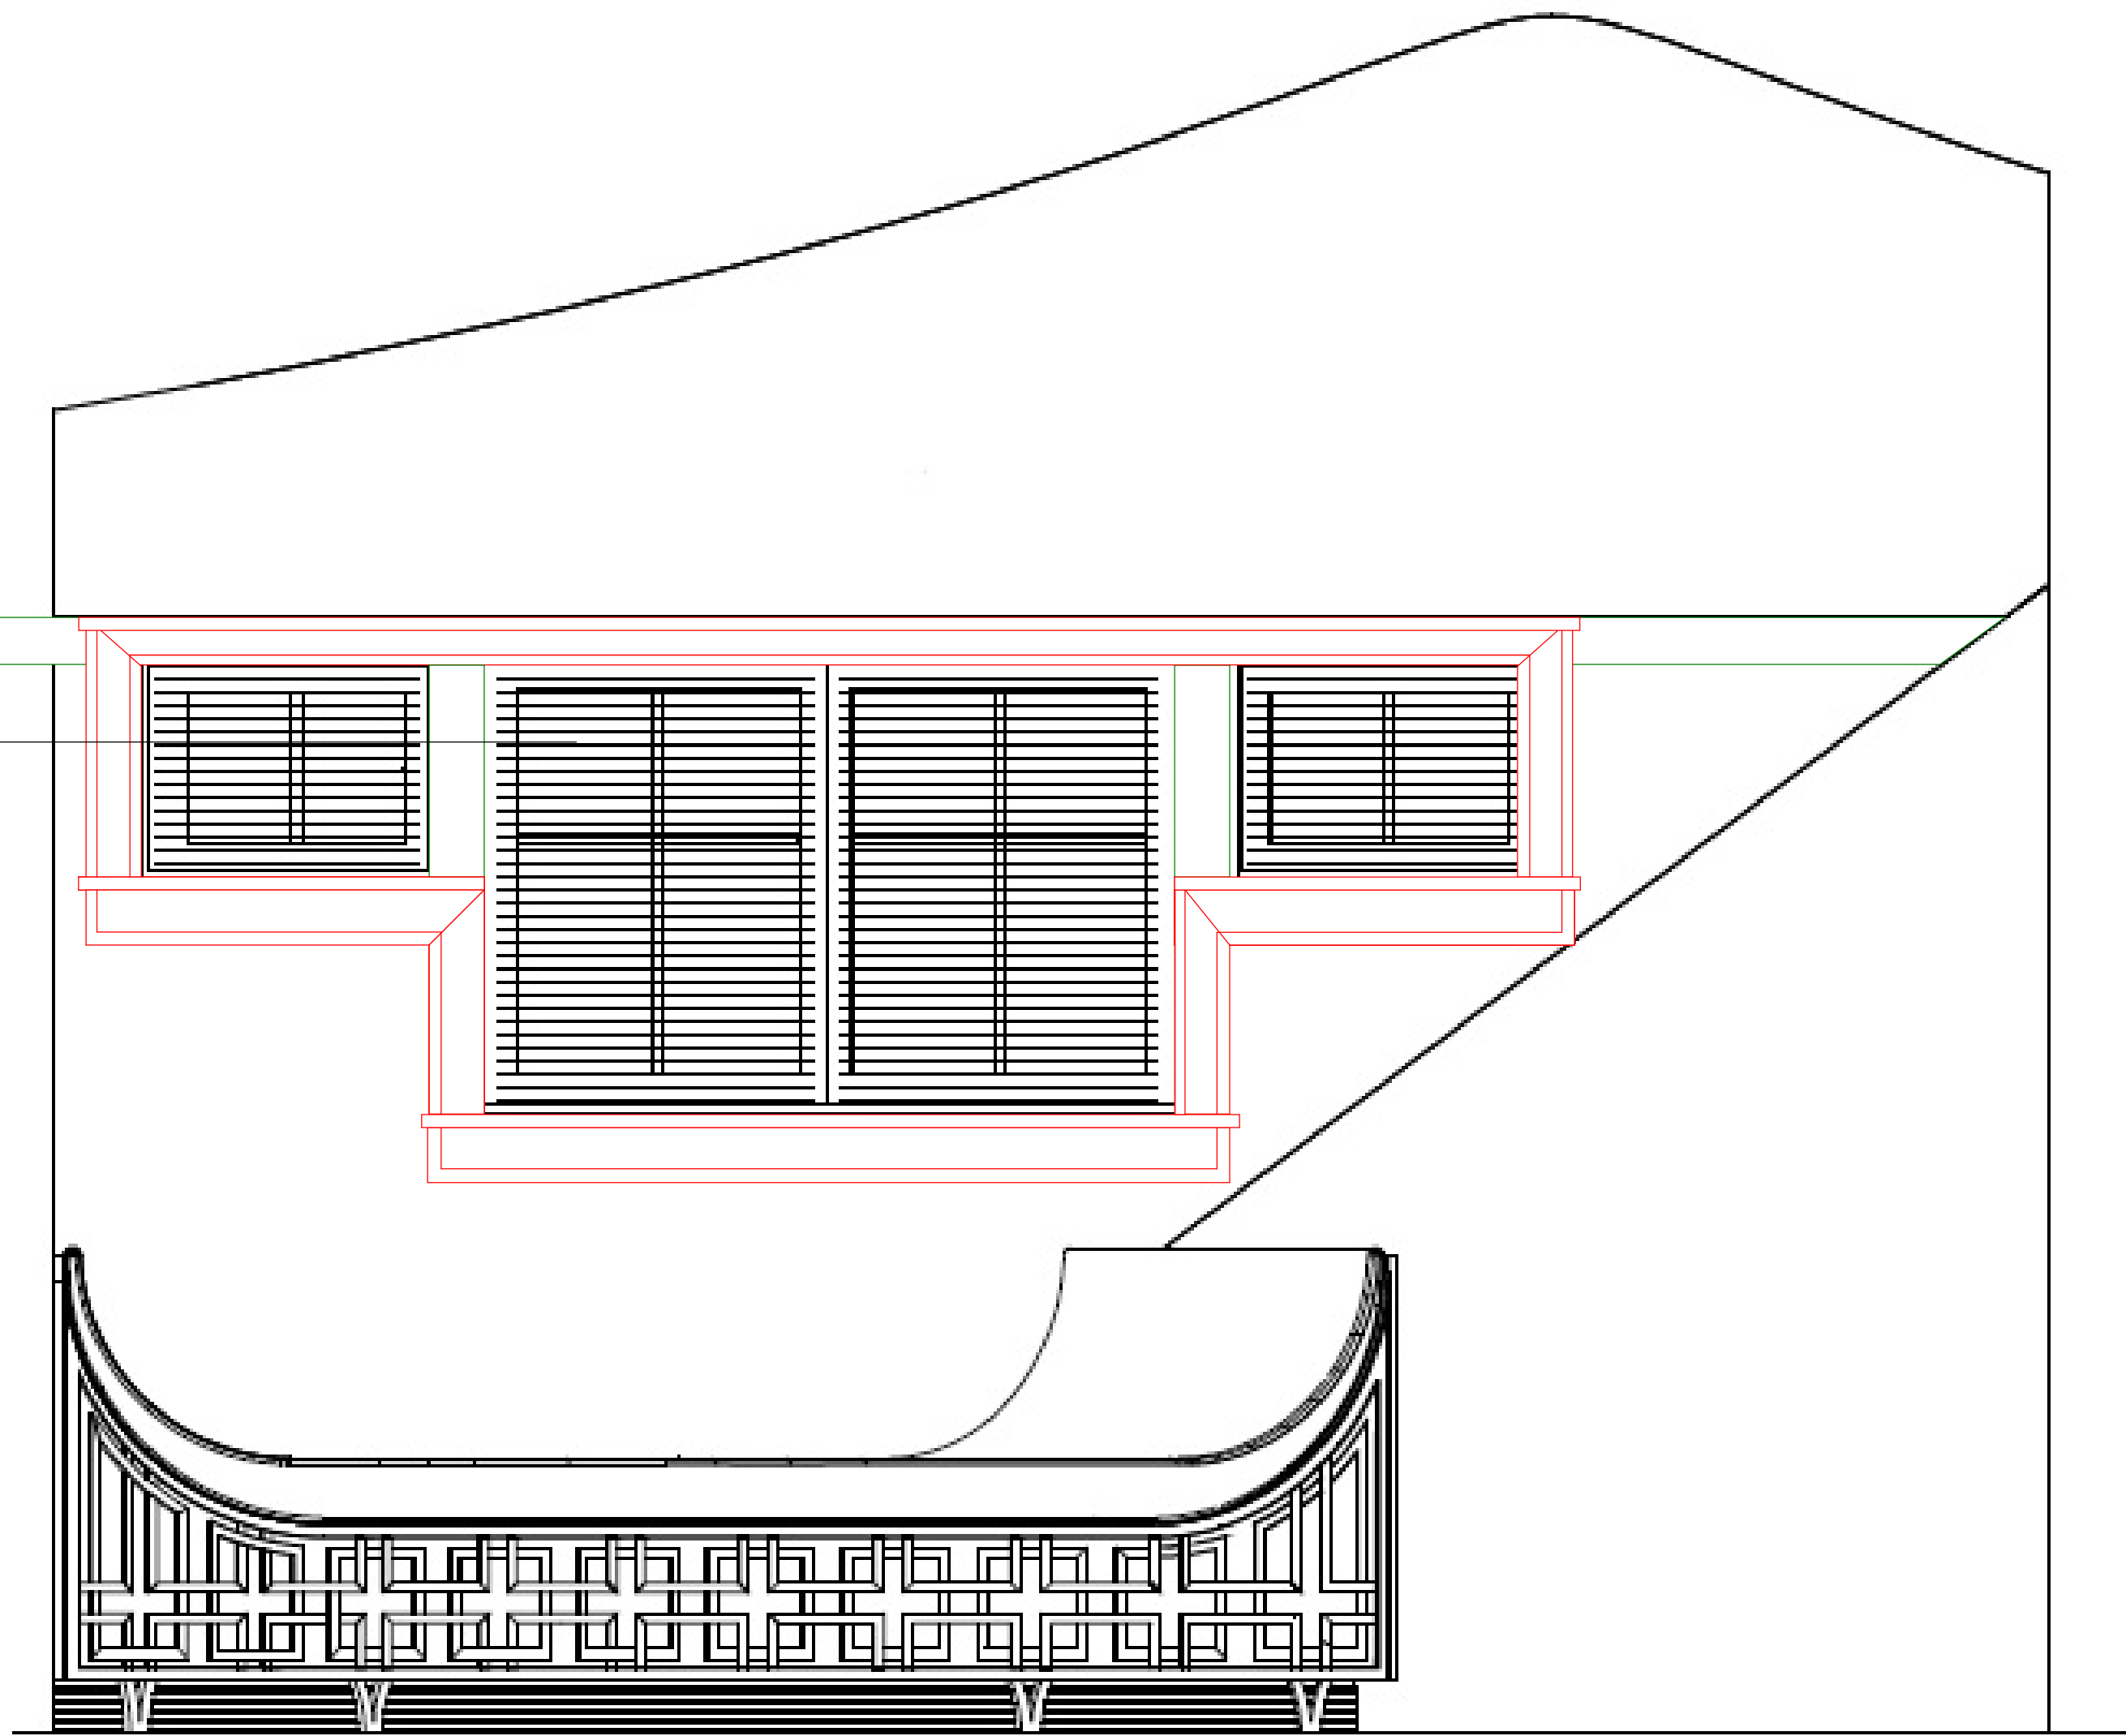

PAUL REGAN ARCHITECT
180 VARICK STREET, SUITE 210
NEW YORK, NEW YORK 10014
TEL: 212 929 2831

MILLS ATTIC
111 QUIMBY LANE BRIDGEHAMPTON NY
25 March 2015

SK32

Webb Builders, Inc.
Design and Construction
www.dwebbsite.com

Mill's Renovation
Shop Drawings



DATE:

11/30/2015

SCALE:

SHEET:

10

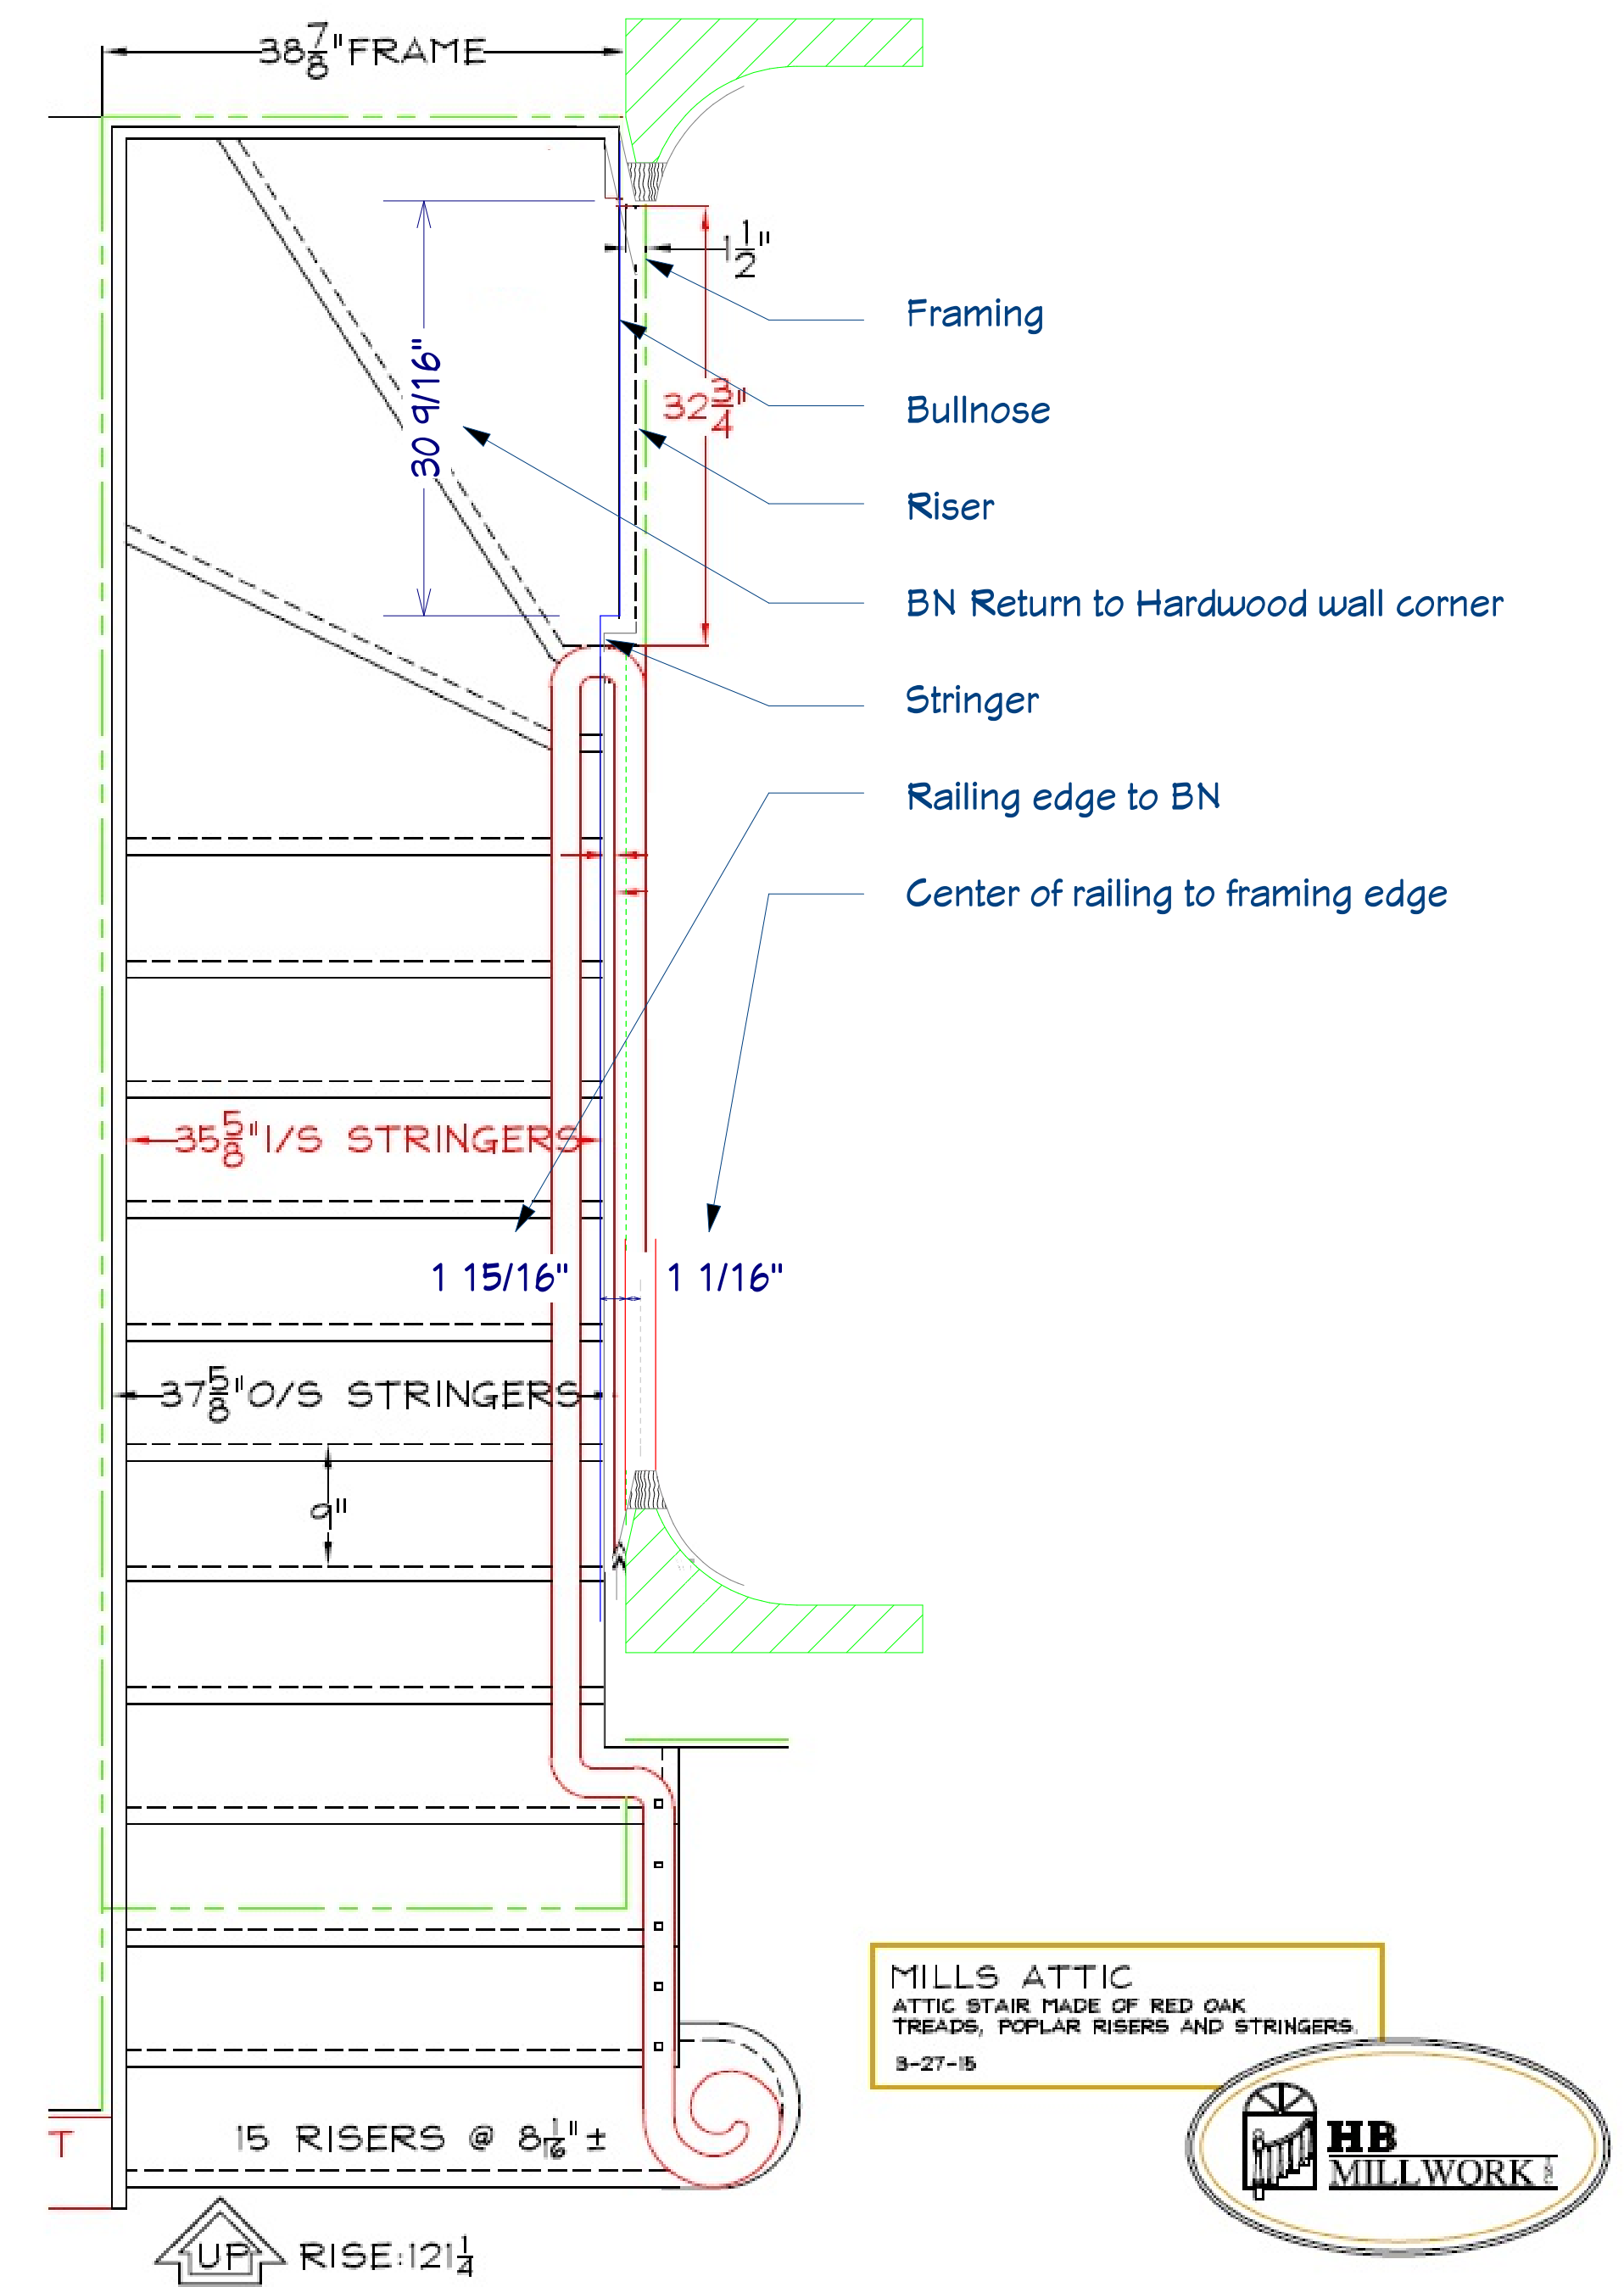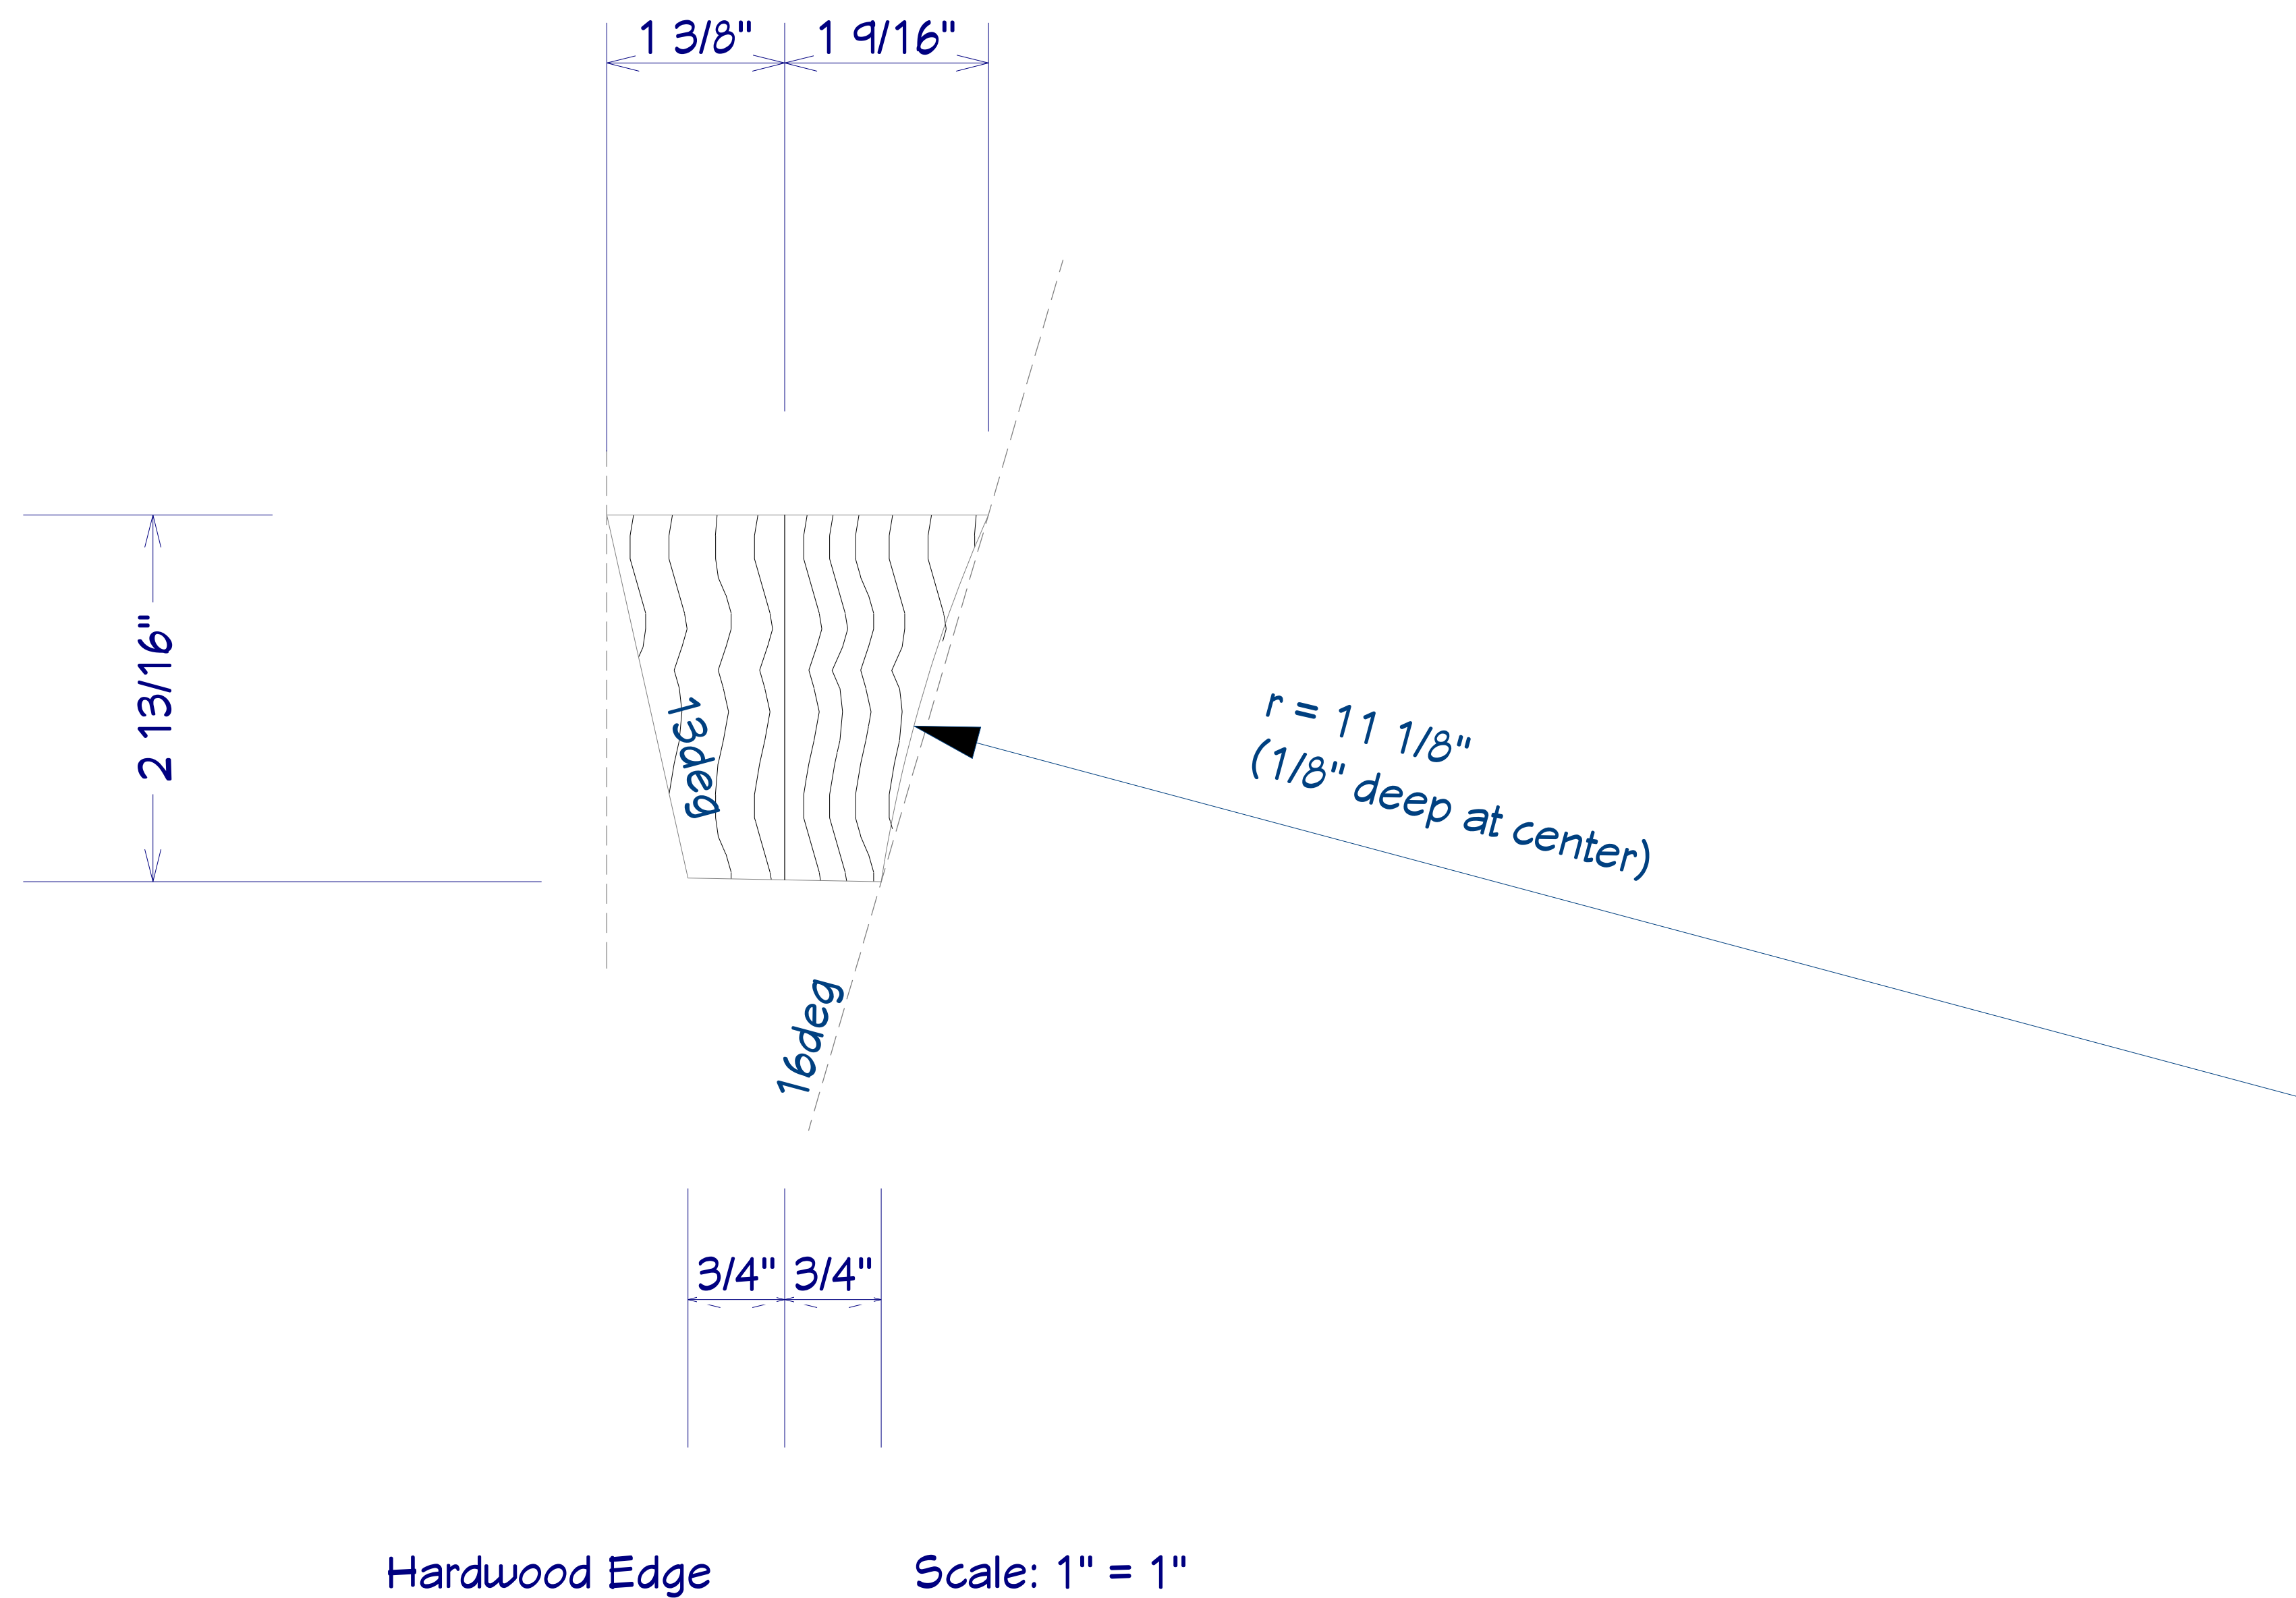

REVISION TABLE		REVISION BY	DESCRIPTION
NUMBER	DATE		

Webb Builders, Inc.
Design and Construction
www.dwebb-site.com

Mill's Renovation
Shop Drawings


DATE:

11/30/2015


SCALE:

SHEET:

11

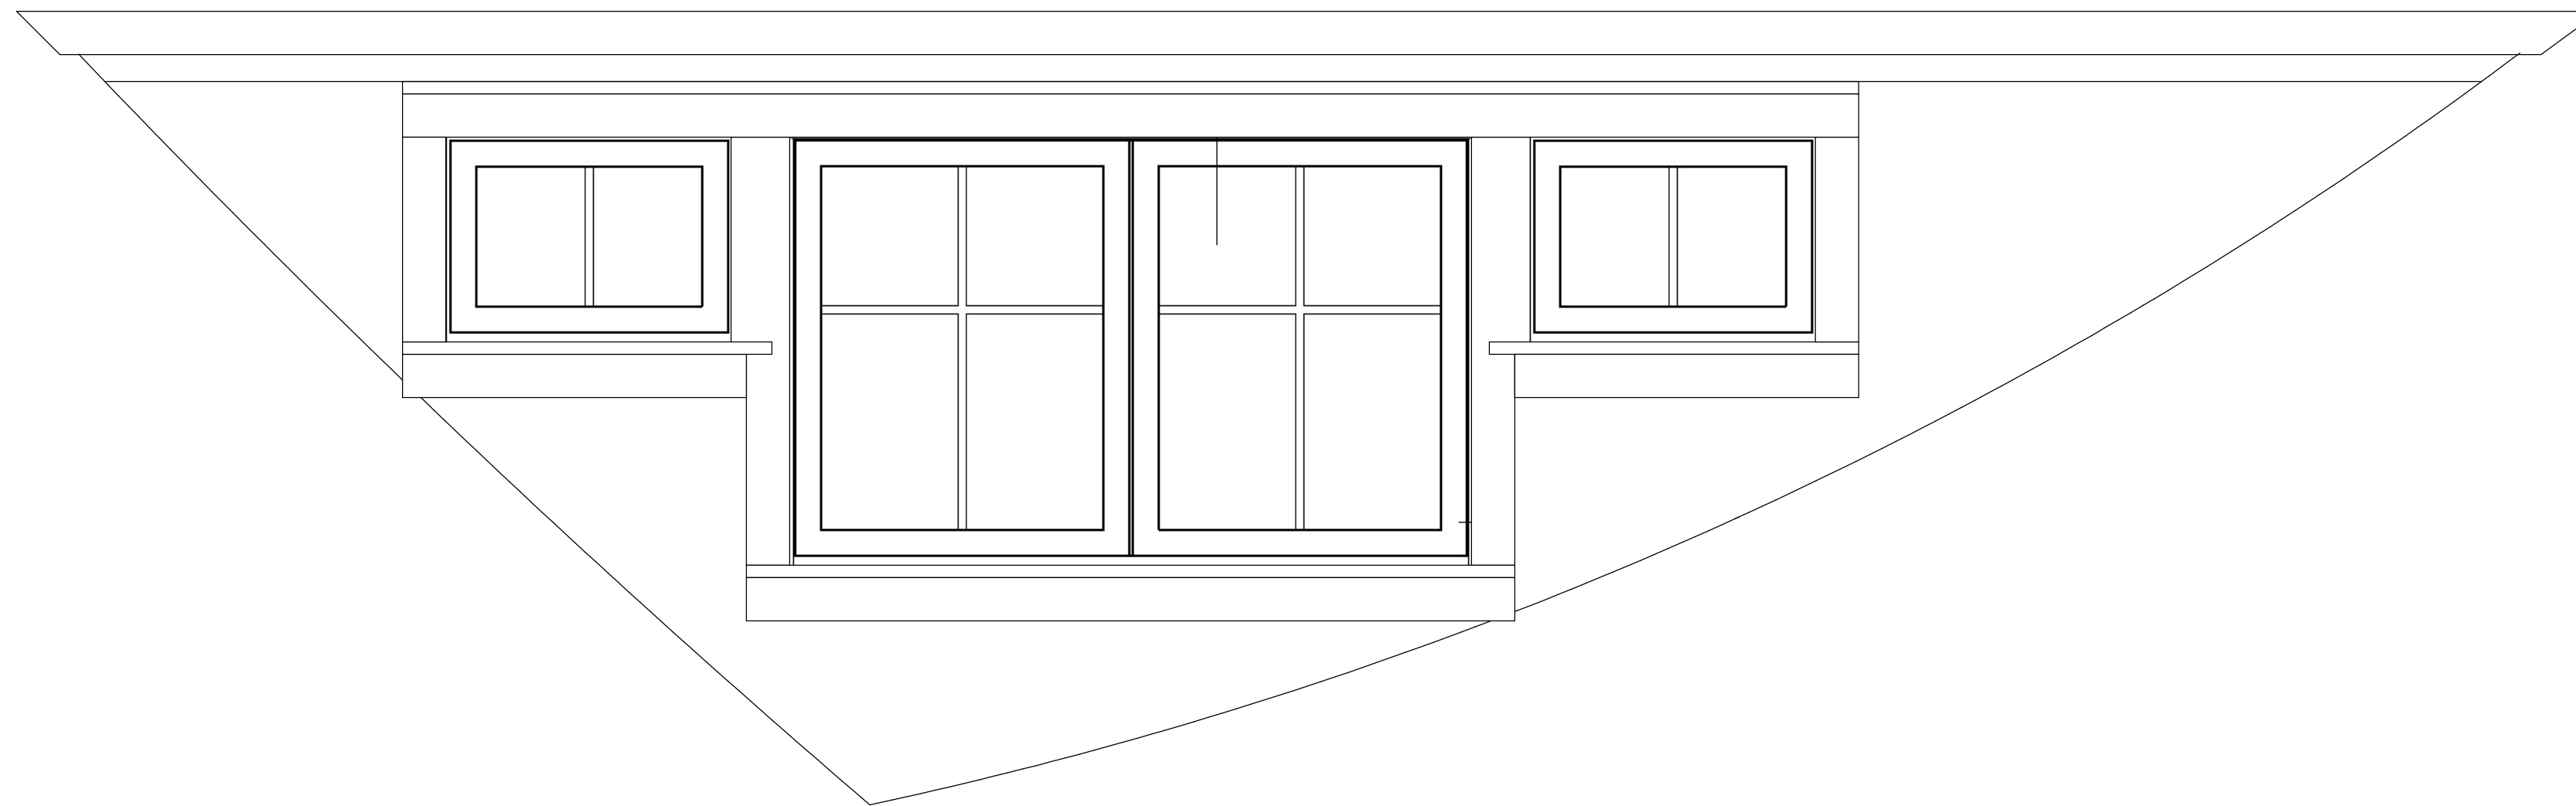

Exterior Window Elevation Scale: 1" = 1'

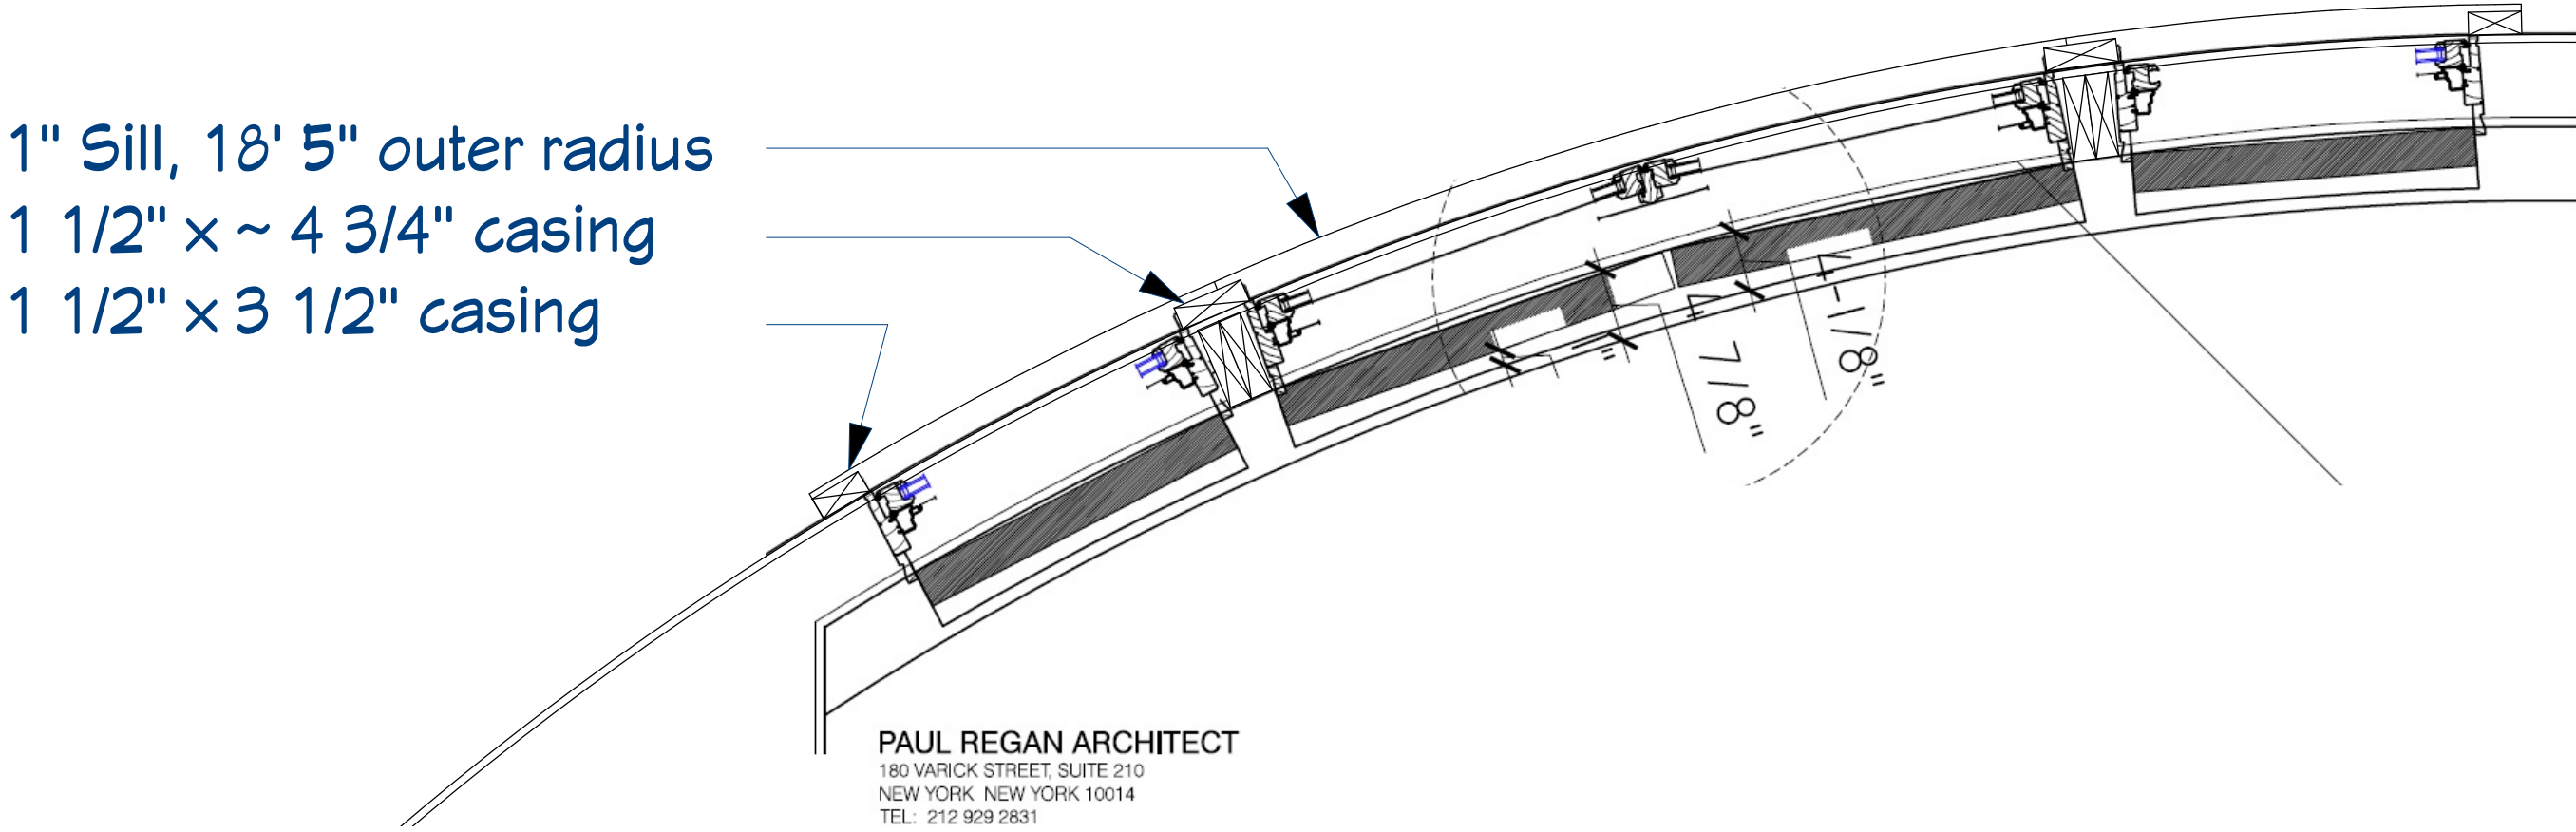

Window Trim Plan (overlaid on drawing by PR) Scale: 1" = 1'

REVISION TABLE		
NUMBER	DATE	REVISION BY / DESCRIPTION

Webb Builders, Inc.
 Design and Construction
www.dwebbste.com

**Mill's Renovation
 Shop Drawings**


DATE:

11/30/2015

SCALE:


SHEET:

12

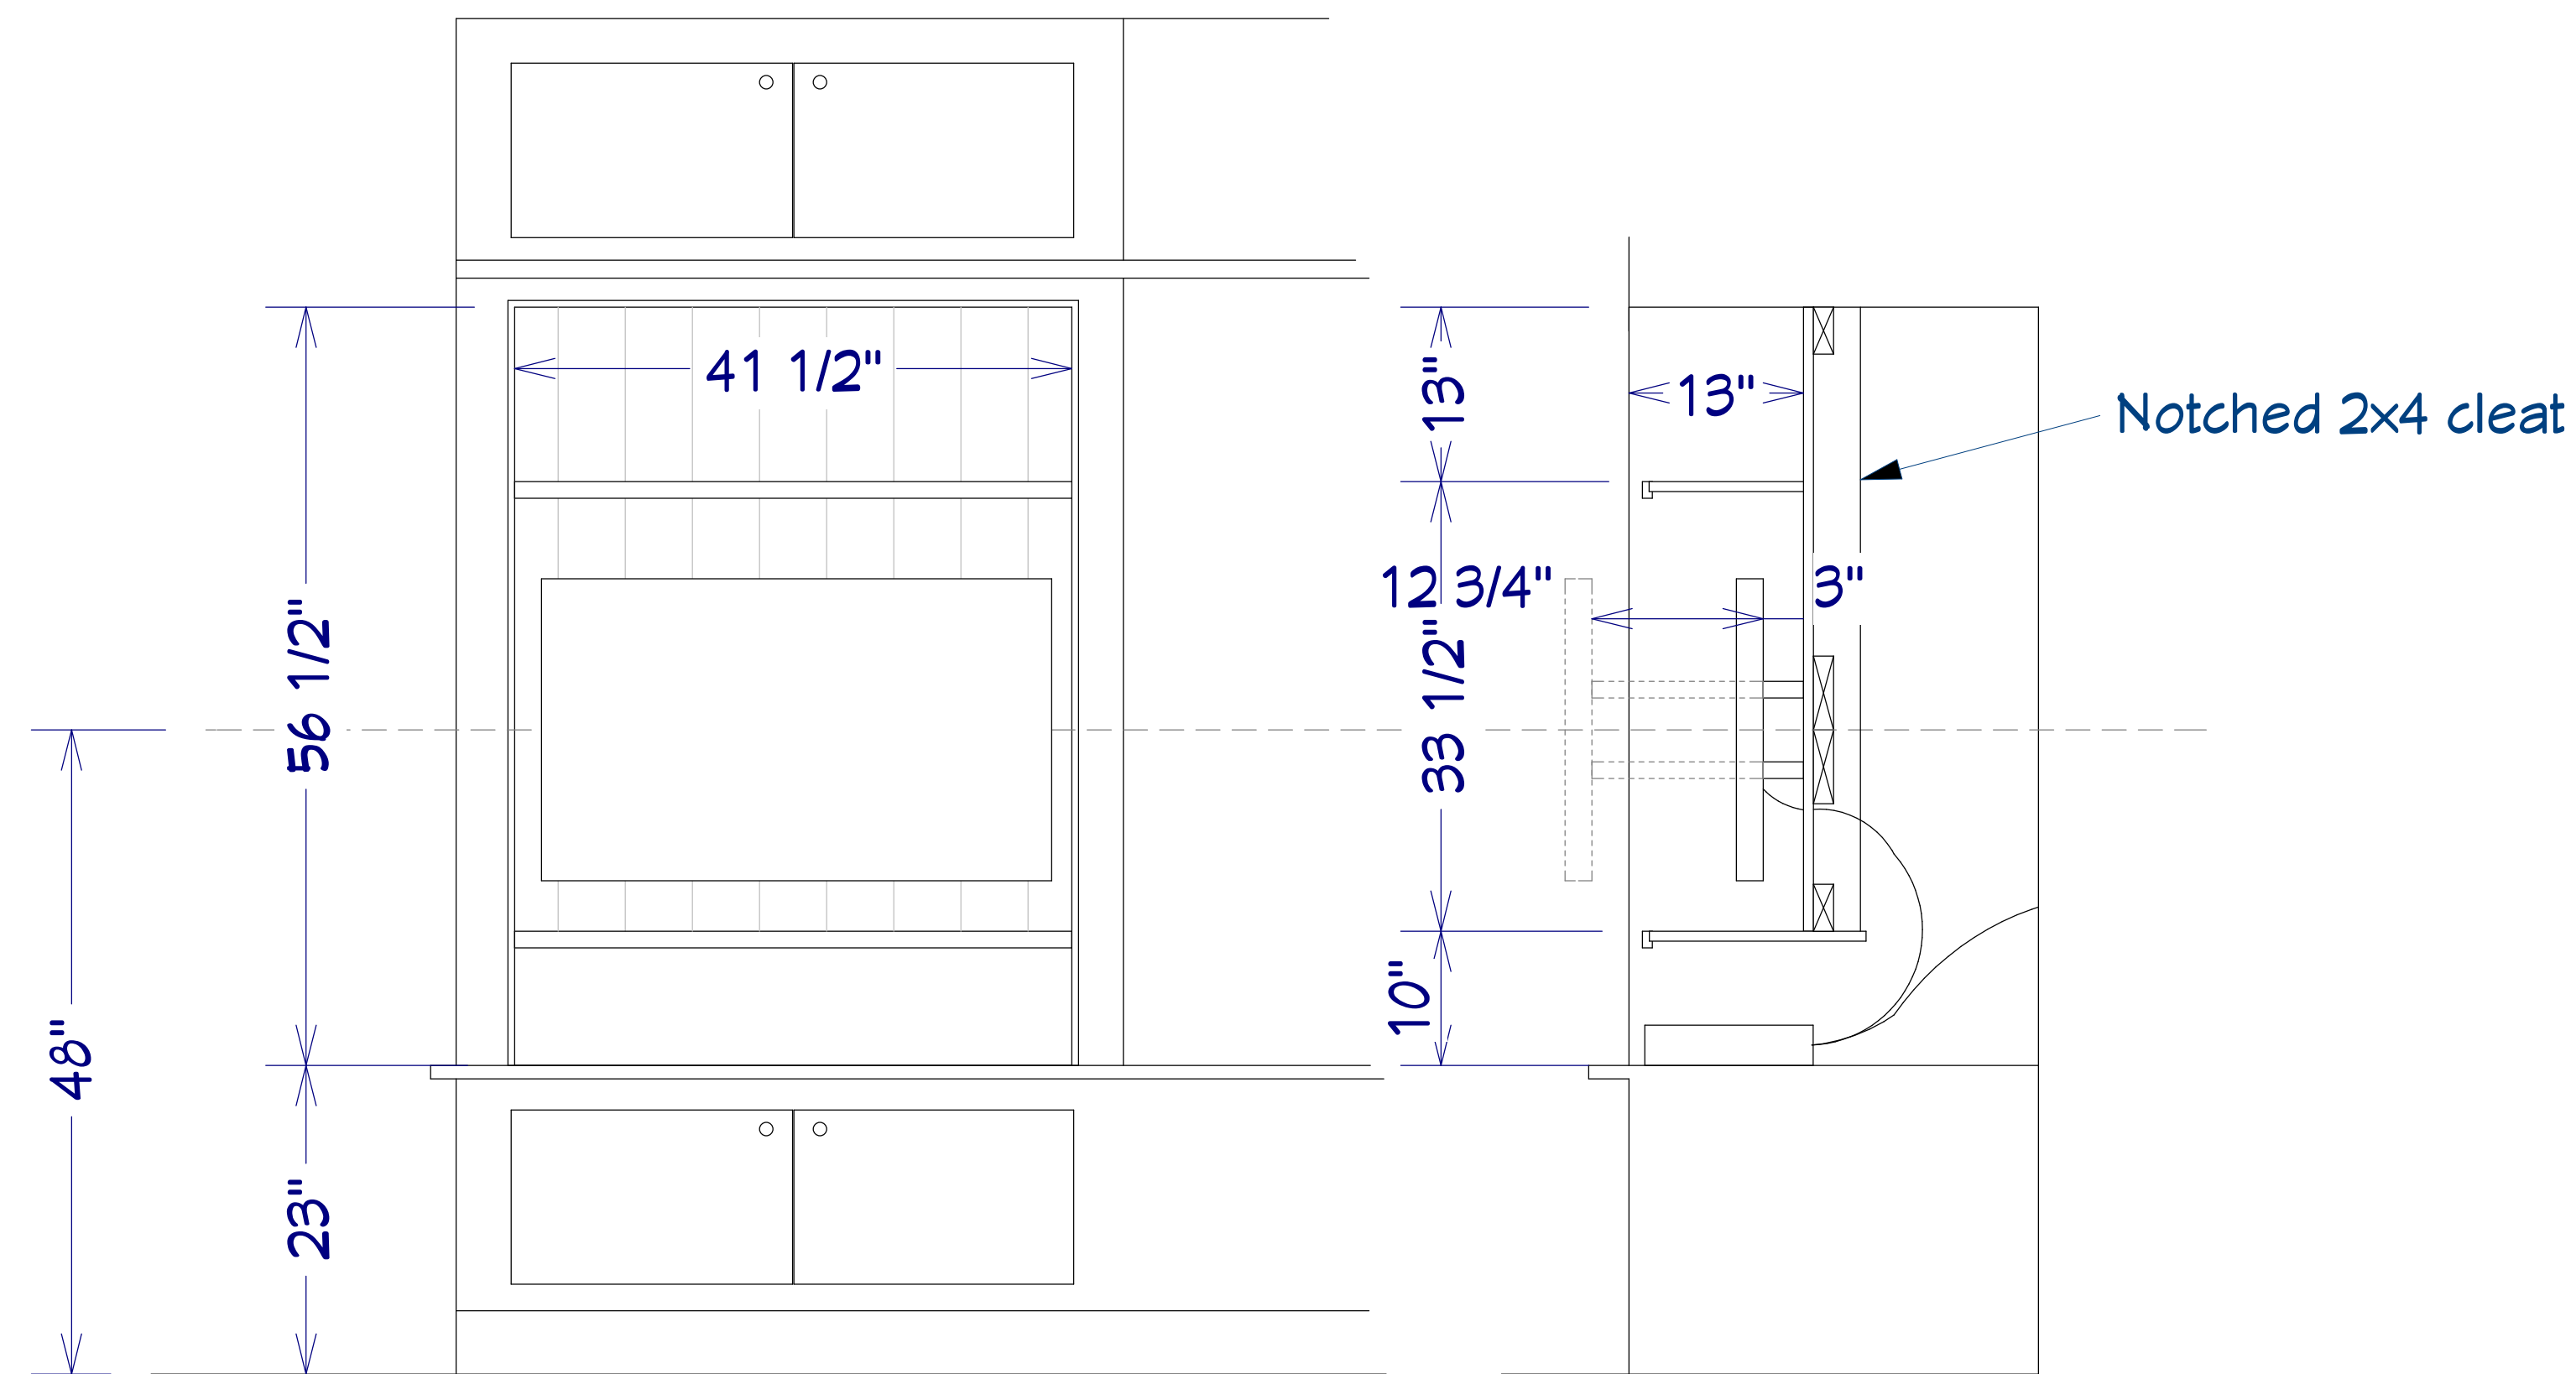

Library TV Nook


Scale: 1" = 1'

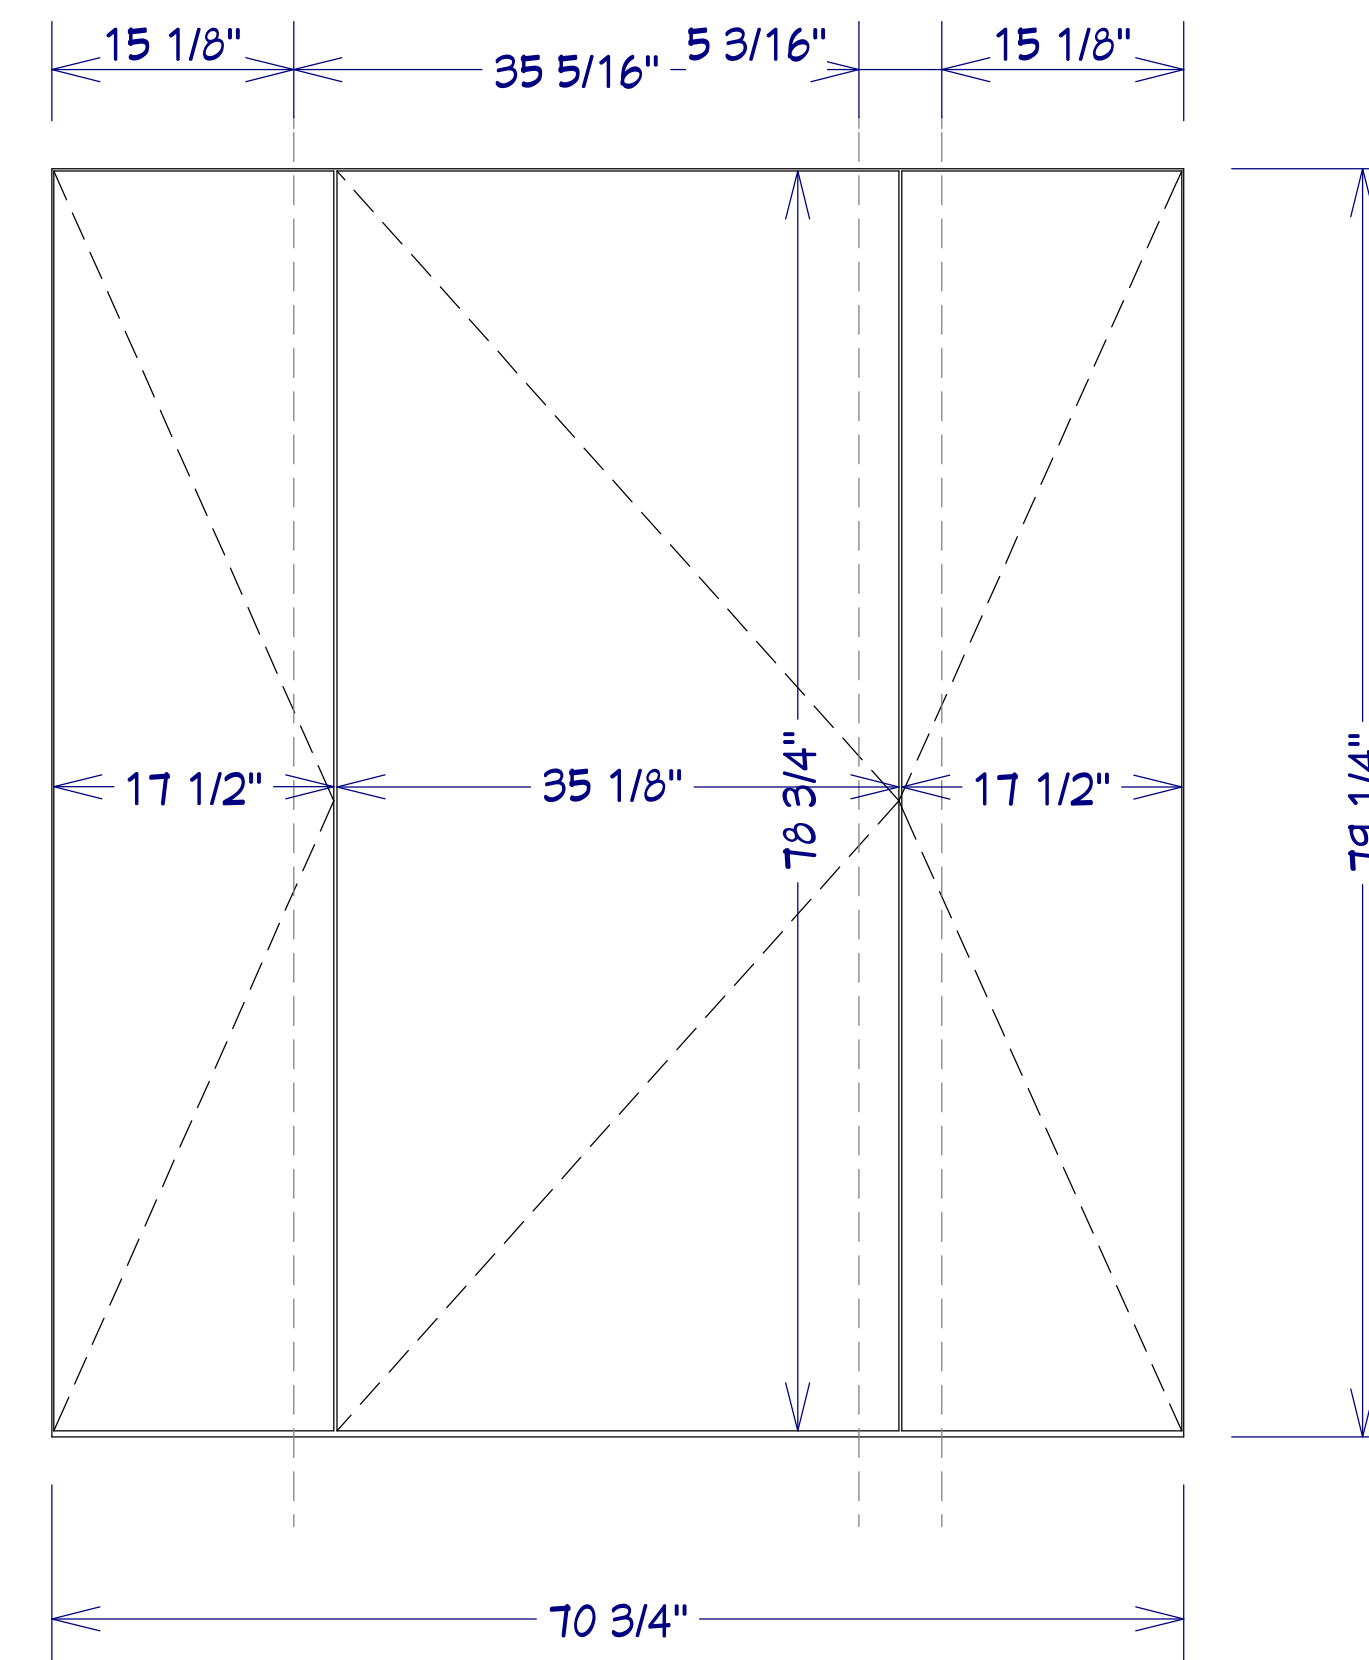

Gaps:
Top = 1/8"
Bottom = 3/8"
In between = 3/16"


Dressing Closet

Scale: 1" = 1'

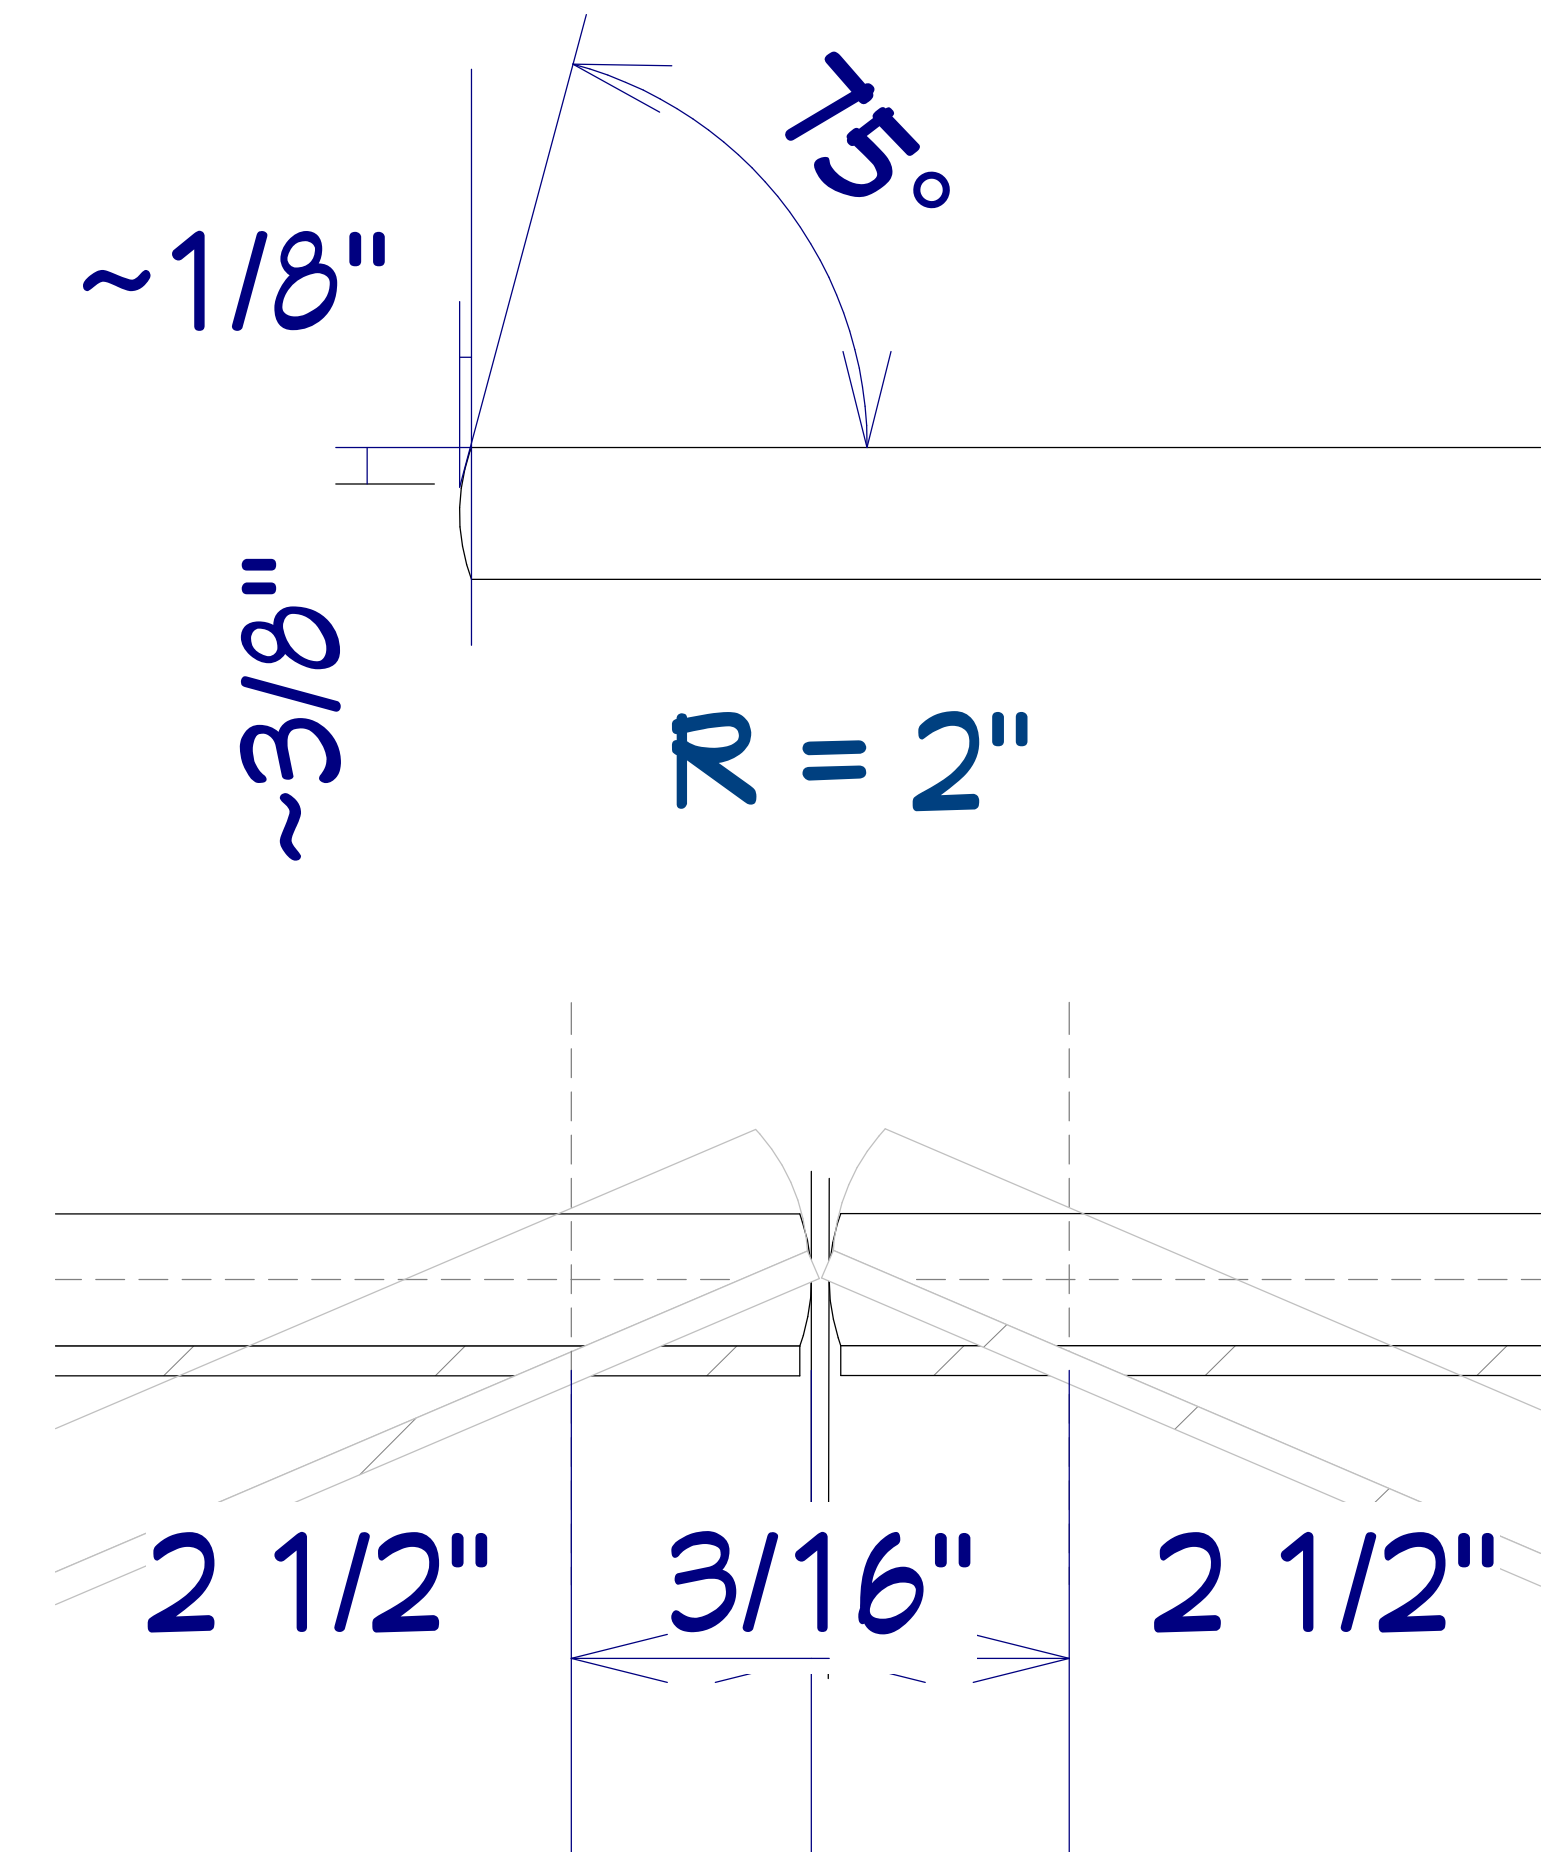


Door edge

Scale: 6" = 1'

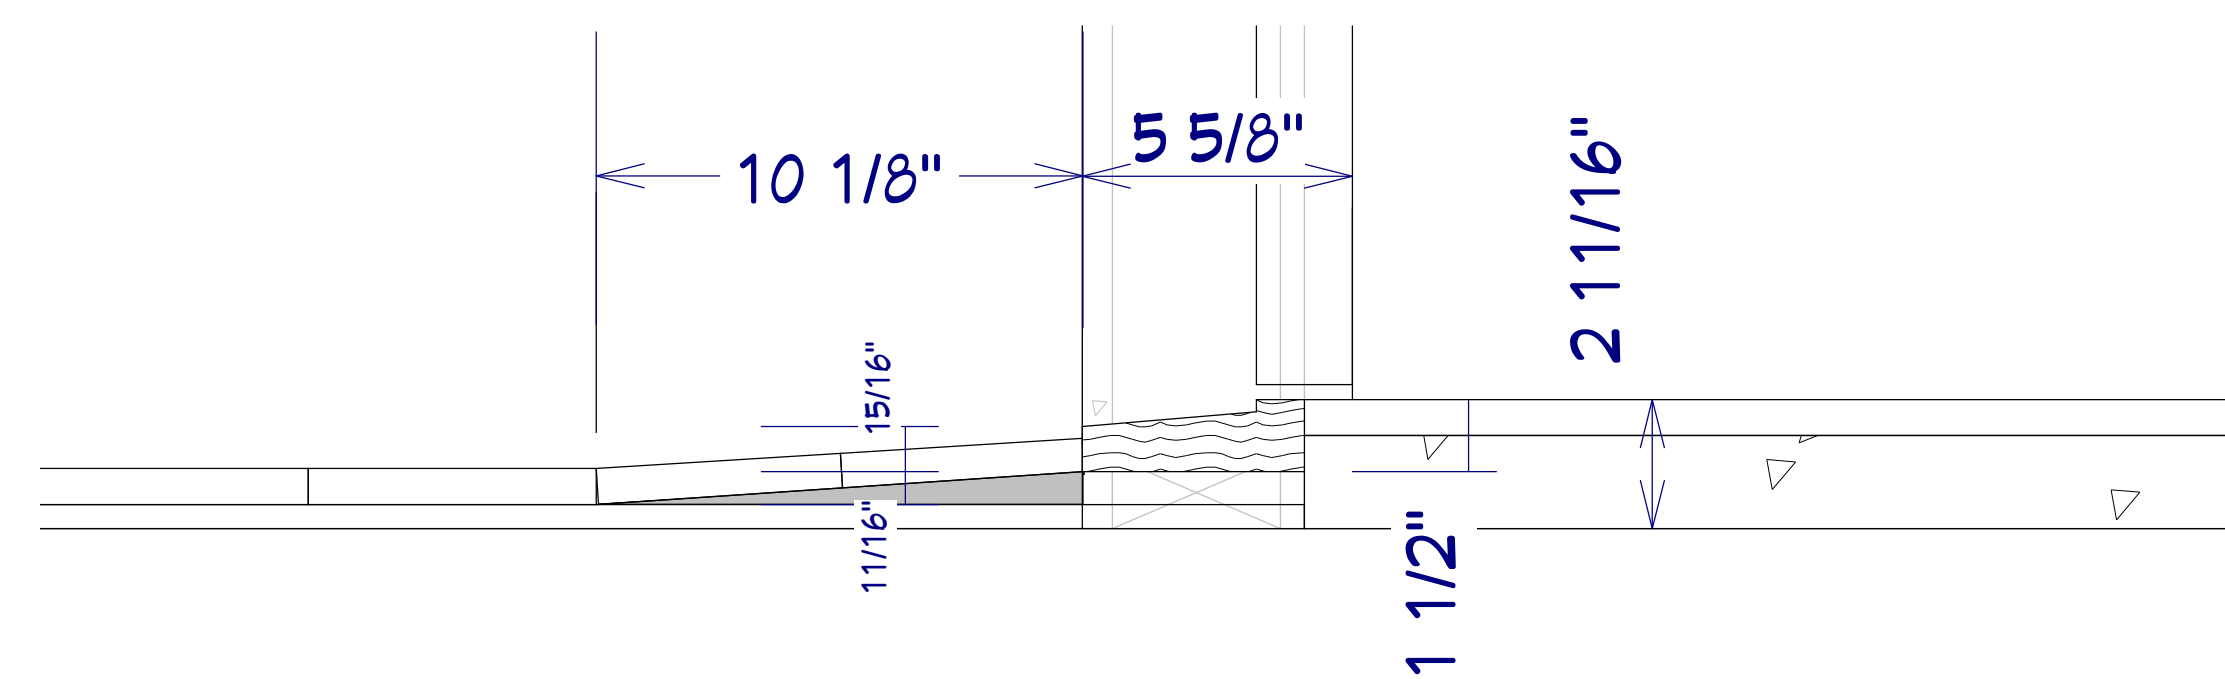


Vanity Ramp

Scale: 3" = 1'

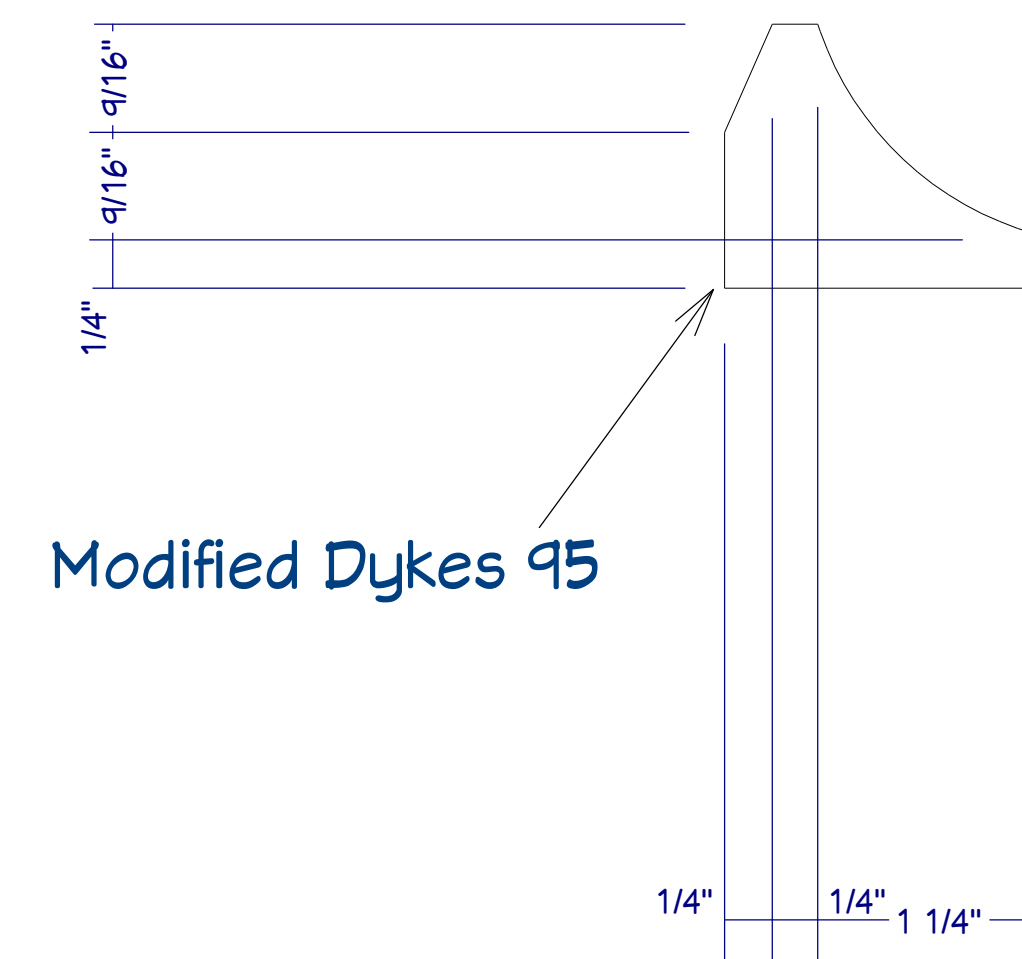

Modified Dykes

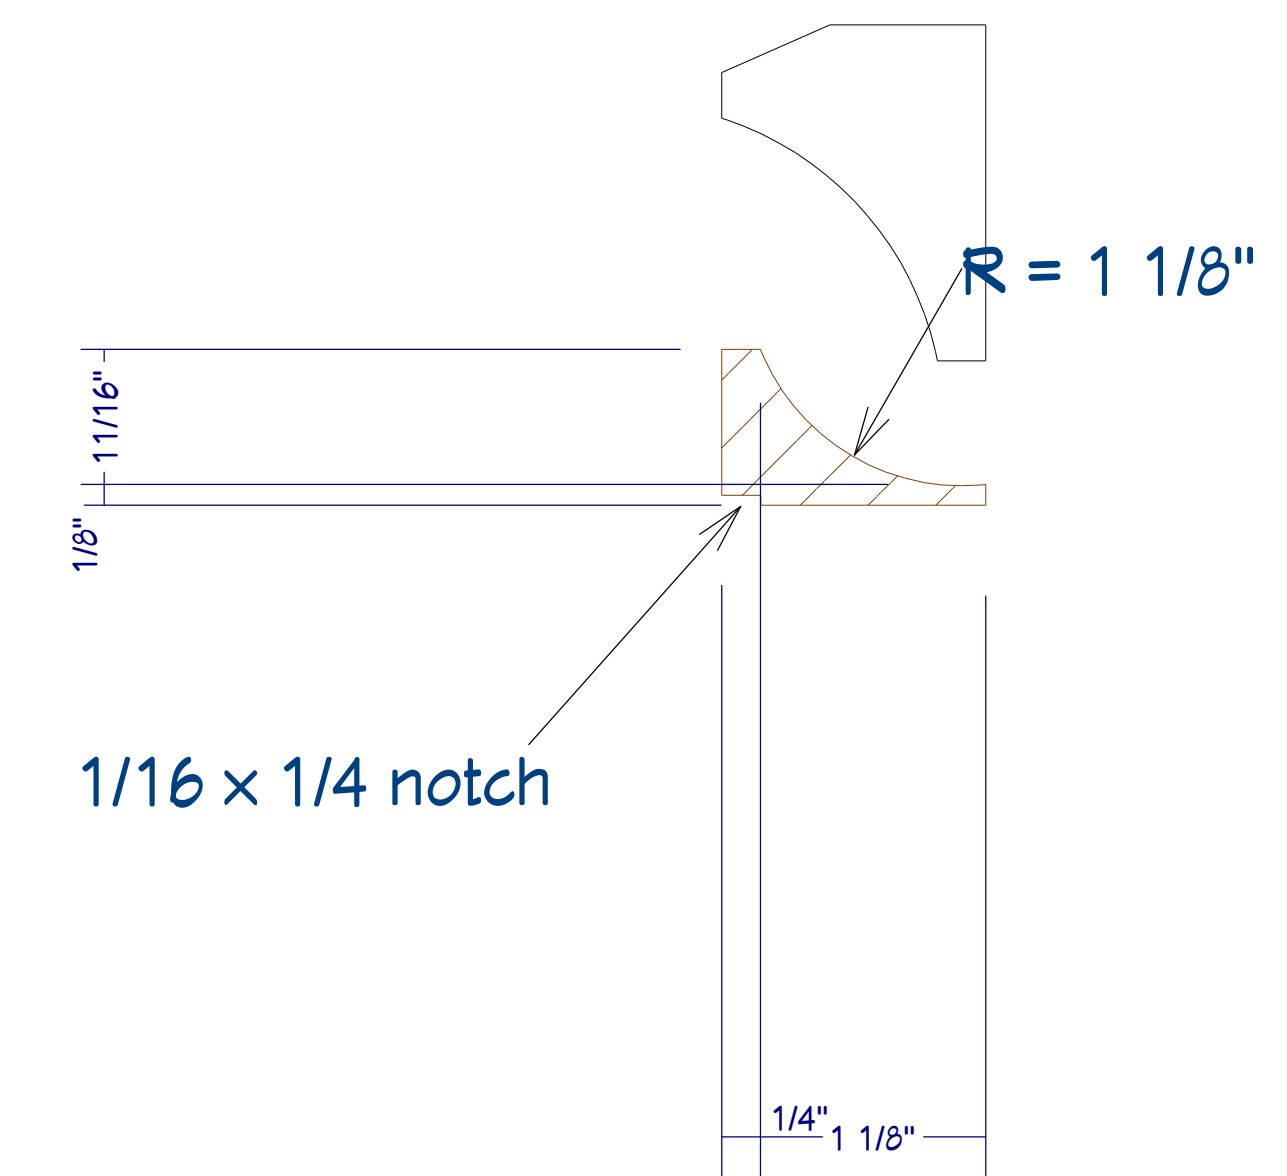

1/16 x 1/4 notch

Custom Cove - need (3) 8' pieces

Custom Cove copes to Dykes

Scale: 1" = 1"

REVISION TABLE	
NUMBER	DATE


Webb Builders, Inc.
Design and Construction
www.dwebbste.com

Mill's Renovation
Shop Drawings

DATE:
11/30/2015

SCALE:

SHEET:
13

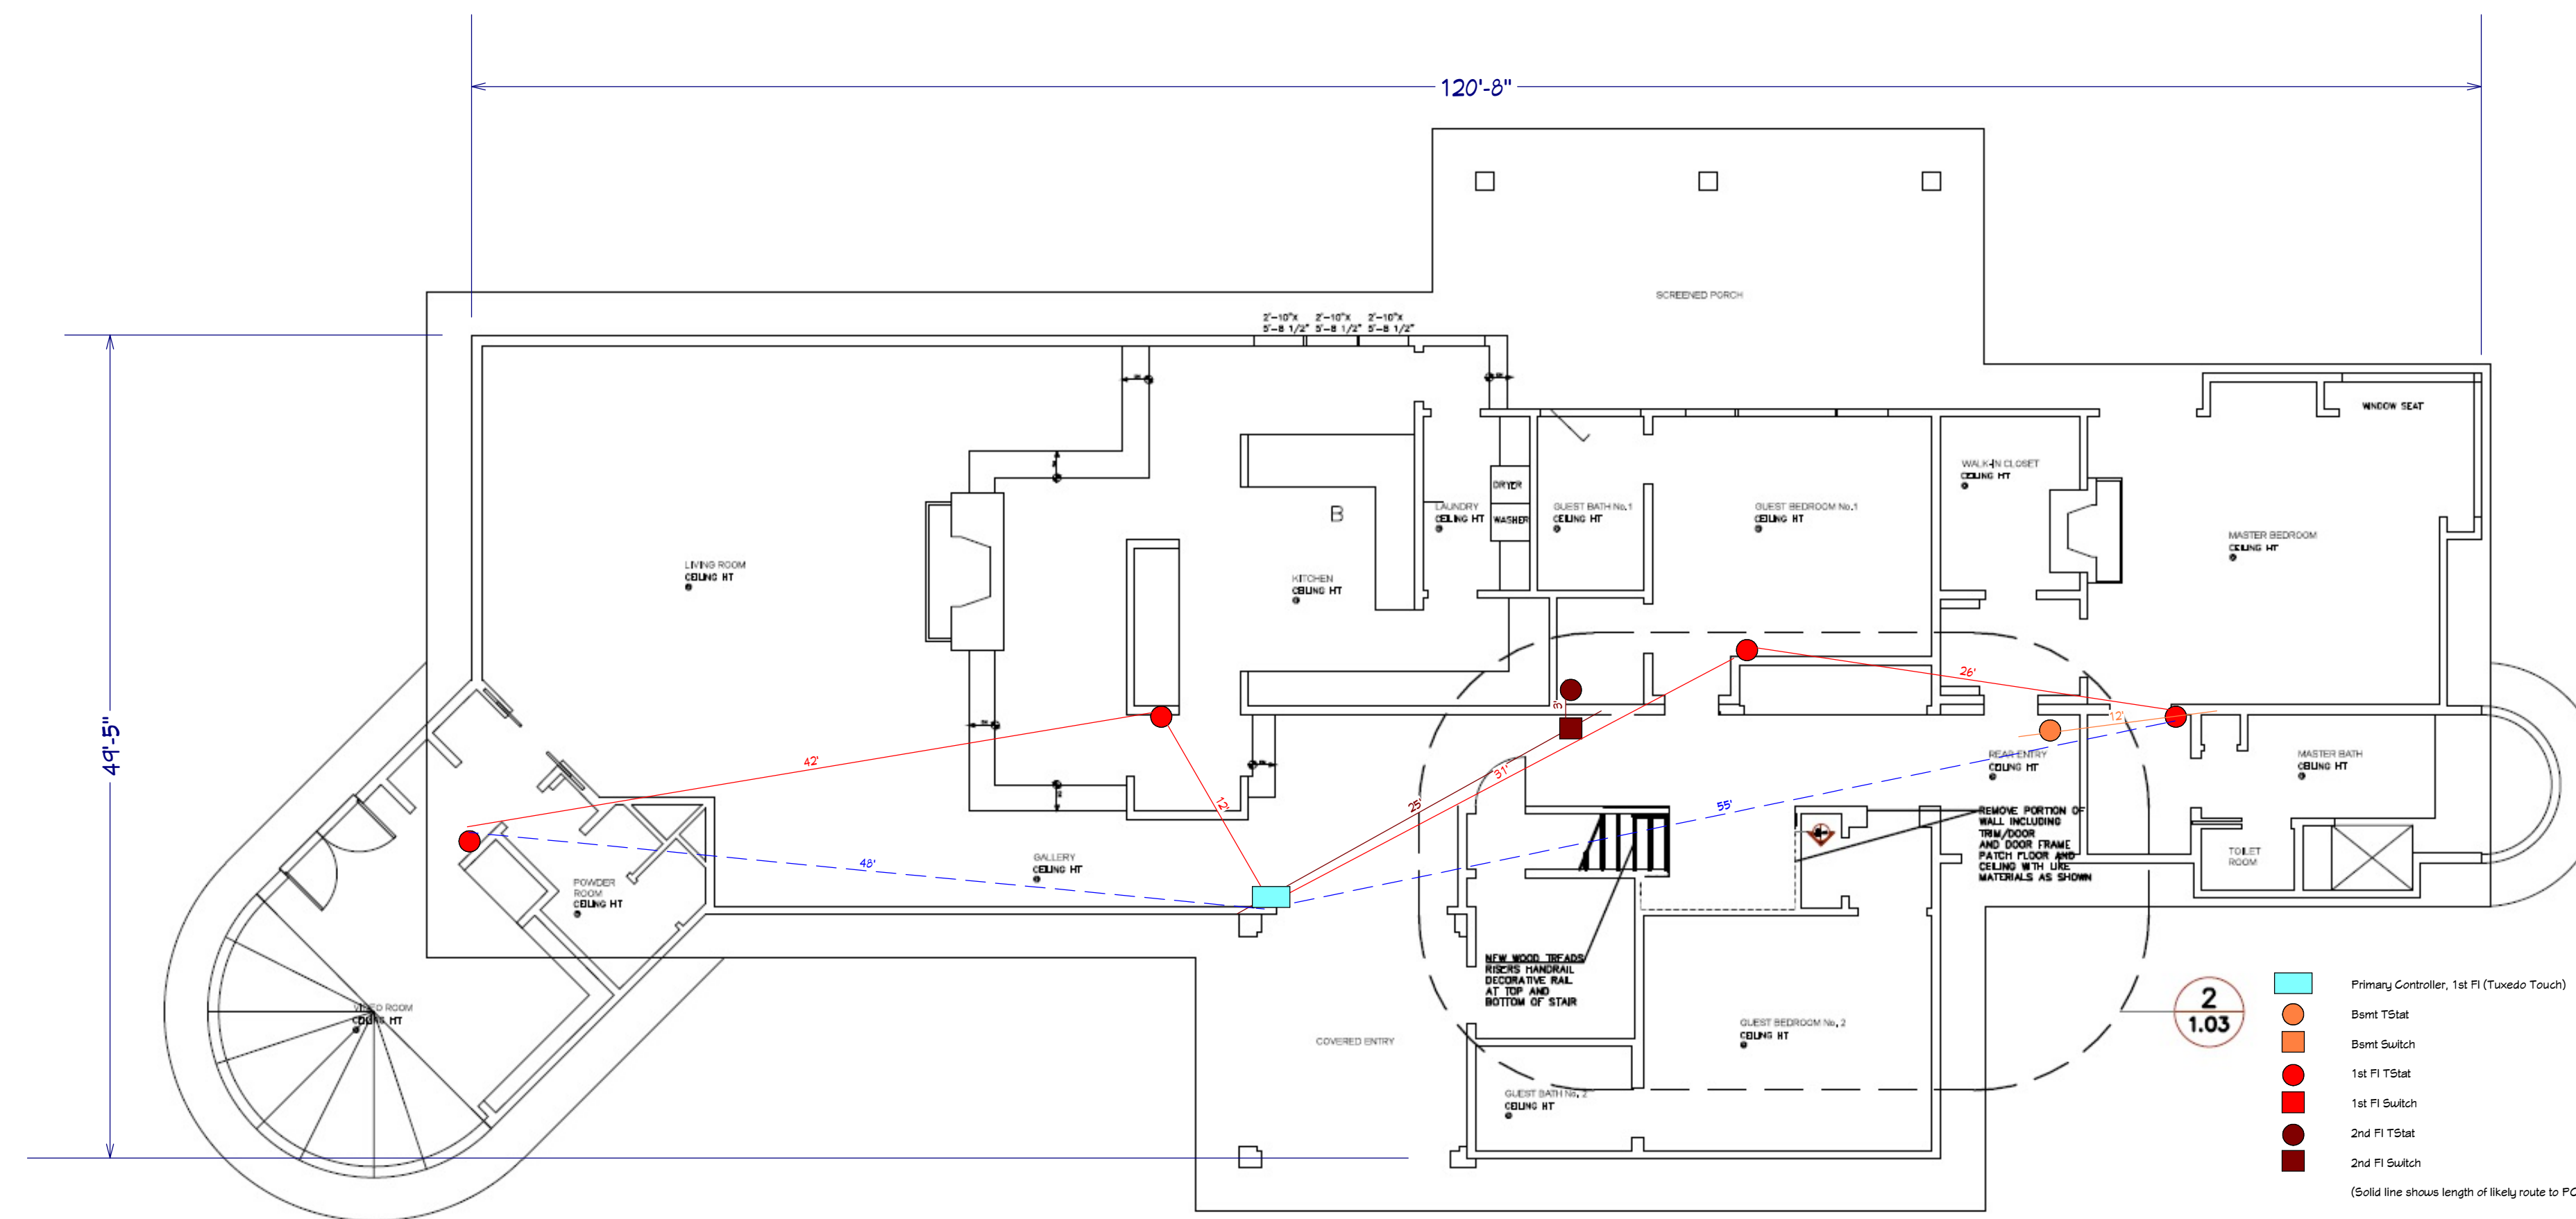

Z Wave Network Topology

	REVISION TABLE		
NUMBER	DATE	REVISED BY	DESCRIPTION

Webb Builders, Inc.
Design and Construction
www.dwebbsite.com

Mill's Renovation Shop Drawings

DATE:

11/30/2015

SCALE:

SHEET: